



PIXL

By:

INVESCA

INDEX OF SHEET		
Discipline	Sheet Number	Sheet Name
SURVEY	SURVEY	TOPOGRAPHIC SURVEY
ARCH	SP-100	OVERALL KEY MAP
ARCH	SP-101.1	OVERALL SITE PLAN
ARCH	SP-101	SITE PLAN
ARCH	SP-102	SITE PLAN
ARCH	SP-103	SITE PLAN
ARCH	SP-104	CPTED PLAN
ARCH	SP-105	SITE PLAN DETAILS
ARCH	SP-106	PAVEMENT/MATERIALS EXHIBIT
ARCH	SP-107	LOT COVERAGE EXHIBIT
ARCH	LC-001	CONCEPTUAL SITE PLAN
ARCH	LC-002	BUILDING ELEVATIONS
ARCH	LC-003	BUILDING ELEVATIONS
ARCH	LC-004	BUILDING ELEVATIONS
ARCH	LC-101	ZONE 1 POOL&LOUNGE
ARCH	LC-102	ZONE 1 POOL&LOUNGE CHARACTER IMAGES
ARCH	LC-103	ZONE 1 POOL&LOUNGE PERCPECTIVE
ARCH	LC-104	ZONE 2 RELAXATION ZONE
ARCH	LC-105	ZONE 2 RELAXATION ZONE CHARACTER IMAGES
ARCH	LC-106	ZONE 3 HEALTH&WELLNESS
ARCH	LC-107	ZONE 3 HEALTH&WELLNESS CHARACTER IMAGES
ARCH	A101	GROUND LEVEL / BLDG 1,2,3,4 /WEST GROUND LEVEL GARAGE
ARCH	A102	GROUND LEVEL / BLDG 5,6,7,8 / EAST GROUND LEVEL GARAGE
ARCH	A103	RESIDENTIAL LEVEL 2 /BLDG 1,2,3,4 /WEST GARAGE LEVEL 2
ARCH	A104	RESIDENTIAL LEVEL 2 /BLDG 5,6,7,8 / EAST GARAGE LEVEL 2
ARCH	A105	RESIDENTIAL LEVEL 3,4,5 /BLDG 1,2,3,4 /WEST GARAGE LEVEL 3,4,5,6,7, ROOFTOP
ARCH	A106	RESIDENTIAL LEVEL 3,4,5 /BLDG 5,6,7,8 / EAST GARAGE LEVEL 3,4,5,6,7
ARCH	A107	RESIDENTIAL LEVEL 6 /BLDG 1,2,3,4 /NO PARKING

INDEX OF SHEET		
Discipline	Sheet Number	Sheet Name
ARCH	A108	RESIDENTIAL LEVEL 6 /BLDG 5,6,7,8 /NO PARKING
ARCH	A109	ROOF PLAN BLDG 1,2,3,4 / GARAGE WEST
ARCH	A110	ROOF PLAN BLDG 5,6,7,8 / GARAGE EAST
ARCH	A300	NORTH ELEVATION
ARCH	A301	SOUTH ELEVATION
ARCH	A302	WEST & EAST ELEVATION
ARCH	A401	BUILDING SECTIONS
ARCH	A400	BUILDING SECTIONS
ARCH	A500	COMMUNITY CENTER L1 & L2
ARCH	A501	COMMUNITY CENTER ELEVATIONS
ARCH	R1	RENDERINGS
ARCH	R2	RENDERINGS
LANDSCAPE	LD-101	TREE DISPOSITION PLAN
LANDSCAPE	LD-102	EXISTING TREE EXHIBIT (NORTH PERIMETER)
LANDSCAPE	LP-100	OVERALL LANDSCAPE PLAN
LANDSCAPE	LP-101	LANDSCAPE PLAN (CANOPY)
LANDSCAPE	LP-102	LANDSCAPE PLAN (CANOPY)
LANDSCAPE	LP-103	LANDSCAPE PLAN (CANOPY)
LANDSCAPE	LP-104	LANDSCAPE PLAN (LEVEL 3)
LANDSCAPE	LP-201	LANDSCAPE PLAN (UNDERSTORY)
LANDSCAPE	LP-202	LANDSCAPE PLAN (UNDERSTORY)
LANDSCAPE	LP-203	LANDSCAPE PLAN (UNDERSTORY)
LANDSCAPE	LP-301	LANDSCAPE NOTES
LANDSCAPE	LP-501	LANDSCAPE DETAILS
LANDSCAPE	LP-502	LANDSCAPE DETAILS
ARCH	PH-100	OVERALL PHOTOMETRICS PLAN
ARCH	PH-101	PHOTOMETRICS PLAN
ARCH	PH-102	PHOTOMETRICS PLAN

INDEX OF SHEET		
Discipline	Sheet Number	Sheet Name
ARCH	PH-103	PHOTOMETRICS PLAN
ARCH	PH-201	PEDESTRIAN LIGHTING PLAN
ARCH	PH-202	PEDESTRIAN LIGHTING PLAN
CIVIL	GL-001	GENERAL NOTES
CIVIL	GL-002	SPECIAL CONSTRUCTION NOTES
CIVIL	GL-003	CONSTRUCTION SPECIFICATIONS
CIVIL	GL-004	LEGEND&ABBREVIATIONS
CIVIL	CP-101	PAVING, GRADING, AND DRAINAGE PLAN
CIVIL	CP-102	PAVING, GRADING, AND DRAINAGE PLAN
CIVIL	CP-103	PAVING, GRADING, AND DRAINAGE PLAN
CIVIL	CP-501	PAVING AND GRADING DETAILS
CIVIL	CP-502	PAVING AND GRADING DETAILS
CIVIL	CU-101	WATER AND SEWER PLAN
CIVIL	CU-102	WATER AND SEWER PLAN
CIVIL	CU-103	WATER AND SEWER PLAN
CIVIL	CU-104	PRELIMINARY WATER AND SEWER PLAN
CIVIL	CU-501	WATER AND SEWER DETAILS
CIVIL	CU-502	WATER AND SEWER DETAILS
CIVIL	CU-503	WATER AND SEWER DETAILS
CIVIL	CU-504	WATER AND SEWER DETAILS
CIVIL	CU-505	WATER AND SEWER DETAILS
CIVIL	CU-506	WATER AND SEWER DETAILS
CIVIL	CU-507	WATER AND SEWER DETAILS
CIVIL	CM-101	PAVEMENT MARKING AND SIGNAGE DETAILS
CIVIL	CM-501	PAVEMENT MARKING AND SIGNAGE DETAILS
CIVIL	CM-502	PAVEMENT MARKING AND SIGNAGE DETAILS



INVESCA

DEVELOPER/OWNER/DESIGNER/BUILDER

INVESCA DEVELOPMENT GROUP, INC

KEITH & ASSOCIATES, INC.

CIVIL ENGINEER &
LANDSCAPE ARCHITECT

PROPERTY ADDRESS
4400 NW 8TH COURT
PLANTATION, FL 33317

CITY COUNCIL SUBMITTAL

MARCH 6, 2019



PIXL

INVESCA
DEVELOPER

REVISIONS

NO.	DESCRIPTION	DATE
1	DRC SUBMITTAL	06-25-18
2	PNZ SUBMITTAL	07-18-18
3	CITY COUNCIL SUBMITTAL	03-06-19

4400 NW 8TH COURT,
PLANTATION FL, 33317

PROJECT
ADDRESS

PIXL

ARCHITECT OF
RECORD

H.L.S. DESIGN
ASSOCIATES INC. A/C
001185
10710 NW 80 CIRCLE
PARKLAND, FL 33076

HARRY MUNOZ - R.A.
AR - 12033

MAR-6-19

DATE

DRAWN

N.R.

JOB #



7901


CHECKED

C.L.




A101

1 Ground Level Bldg 1,2,3,4 and west Garage
1/16" = 1'-0"

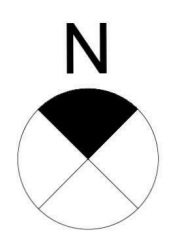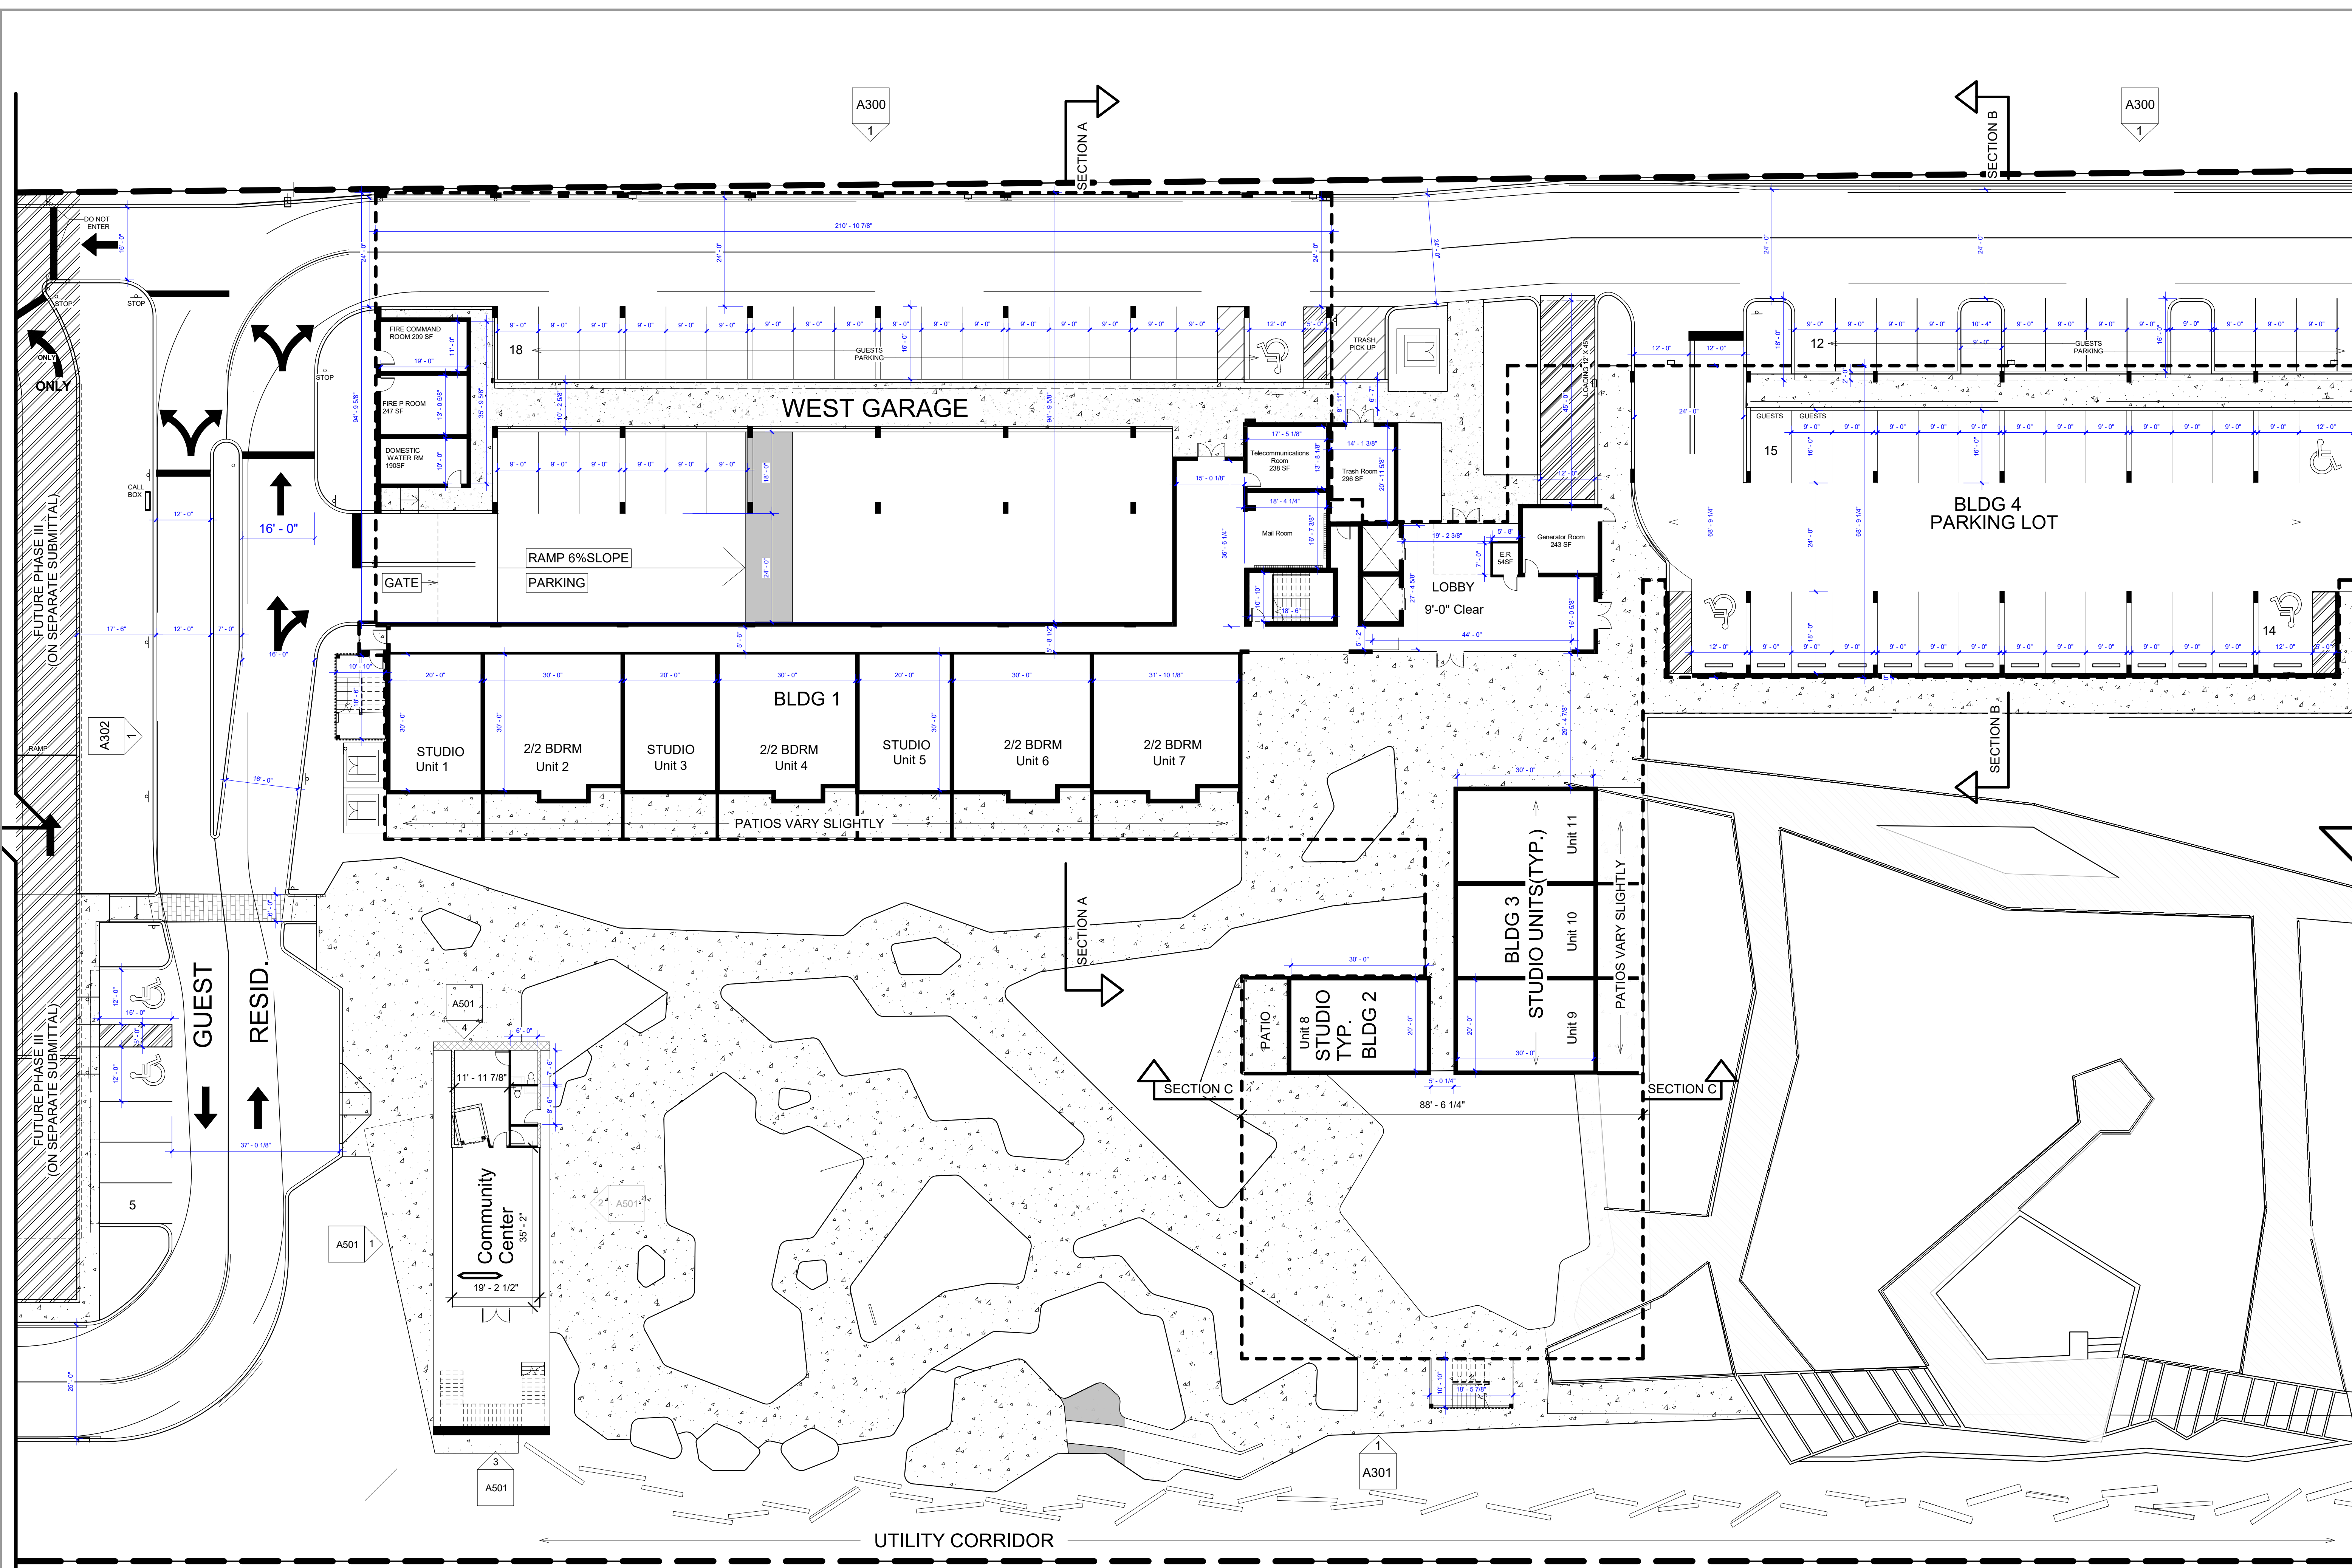

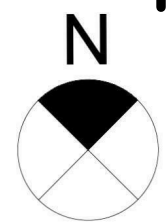

① Ground Level Bldg 5, 6, 7, 8 and East Garage
1/16" = 1'-0"

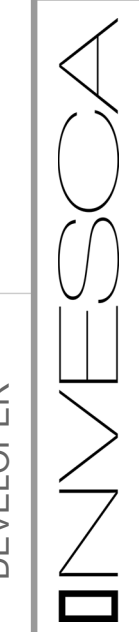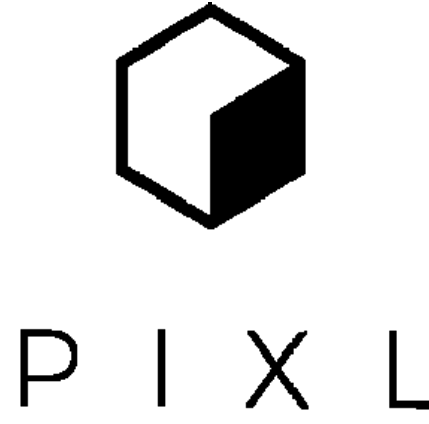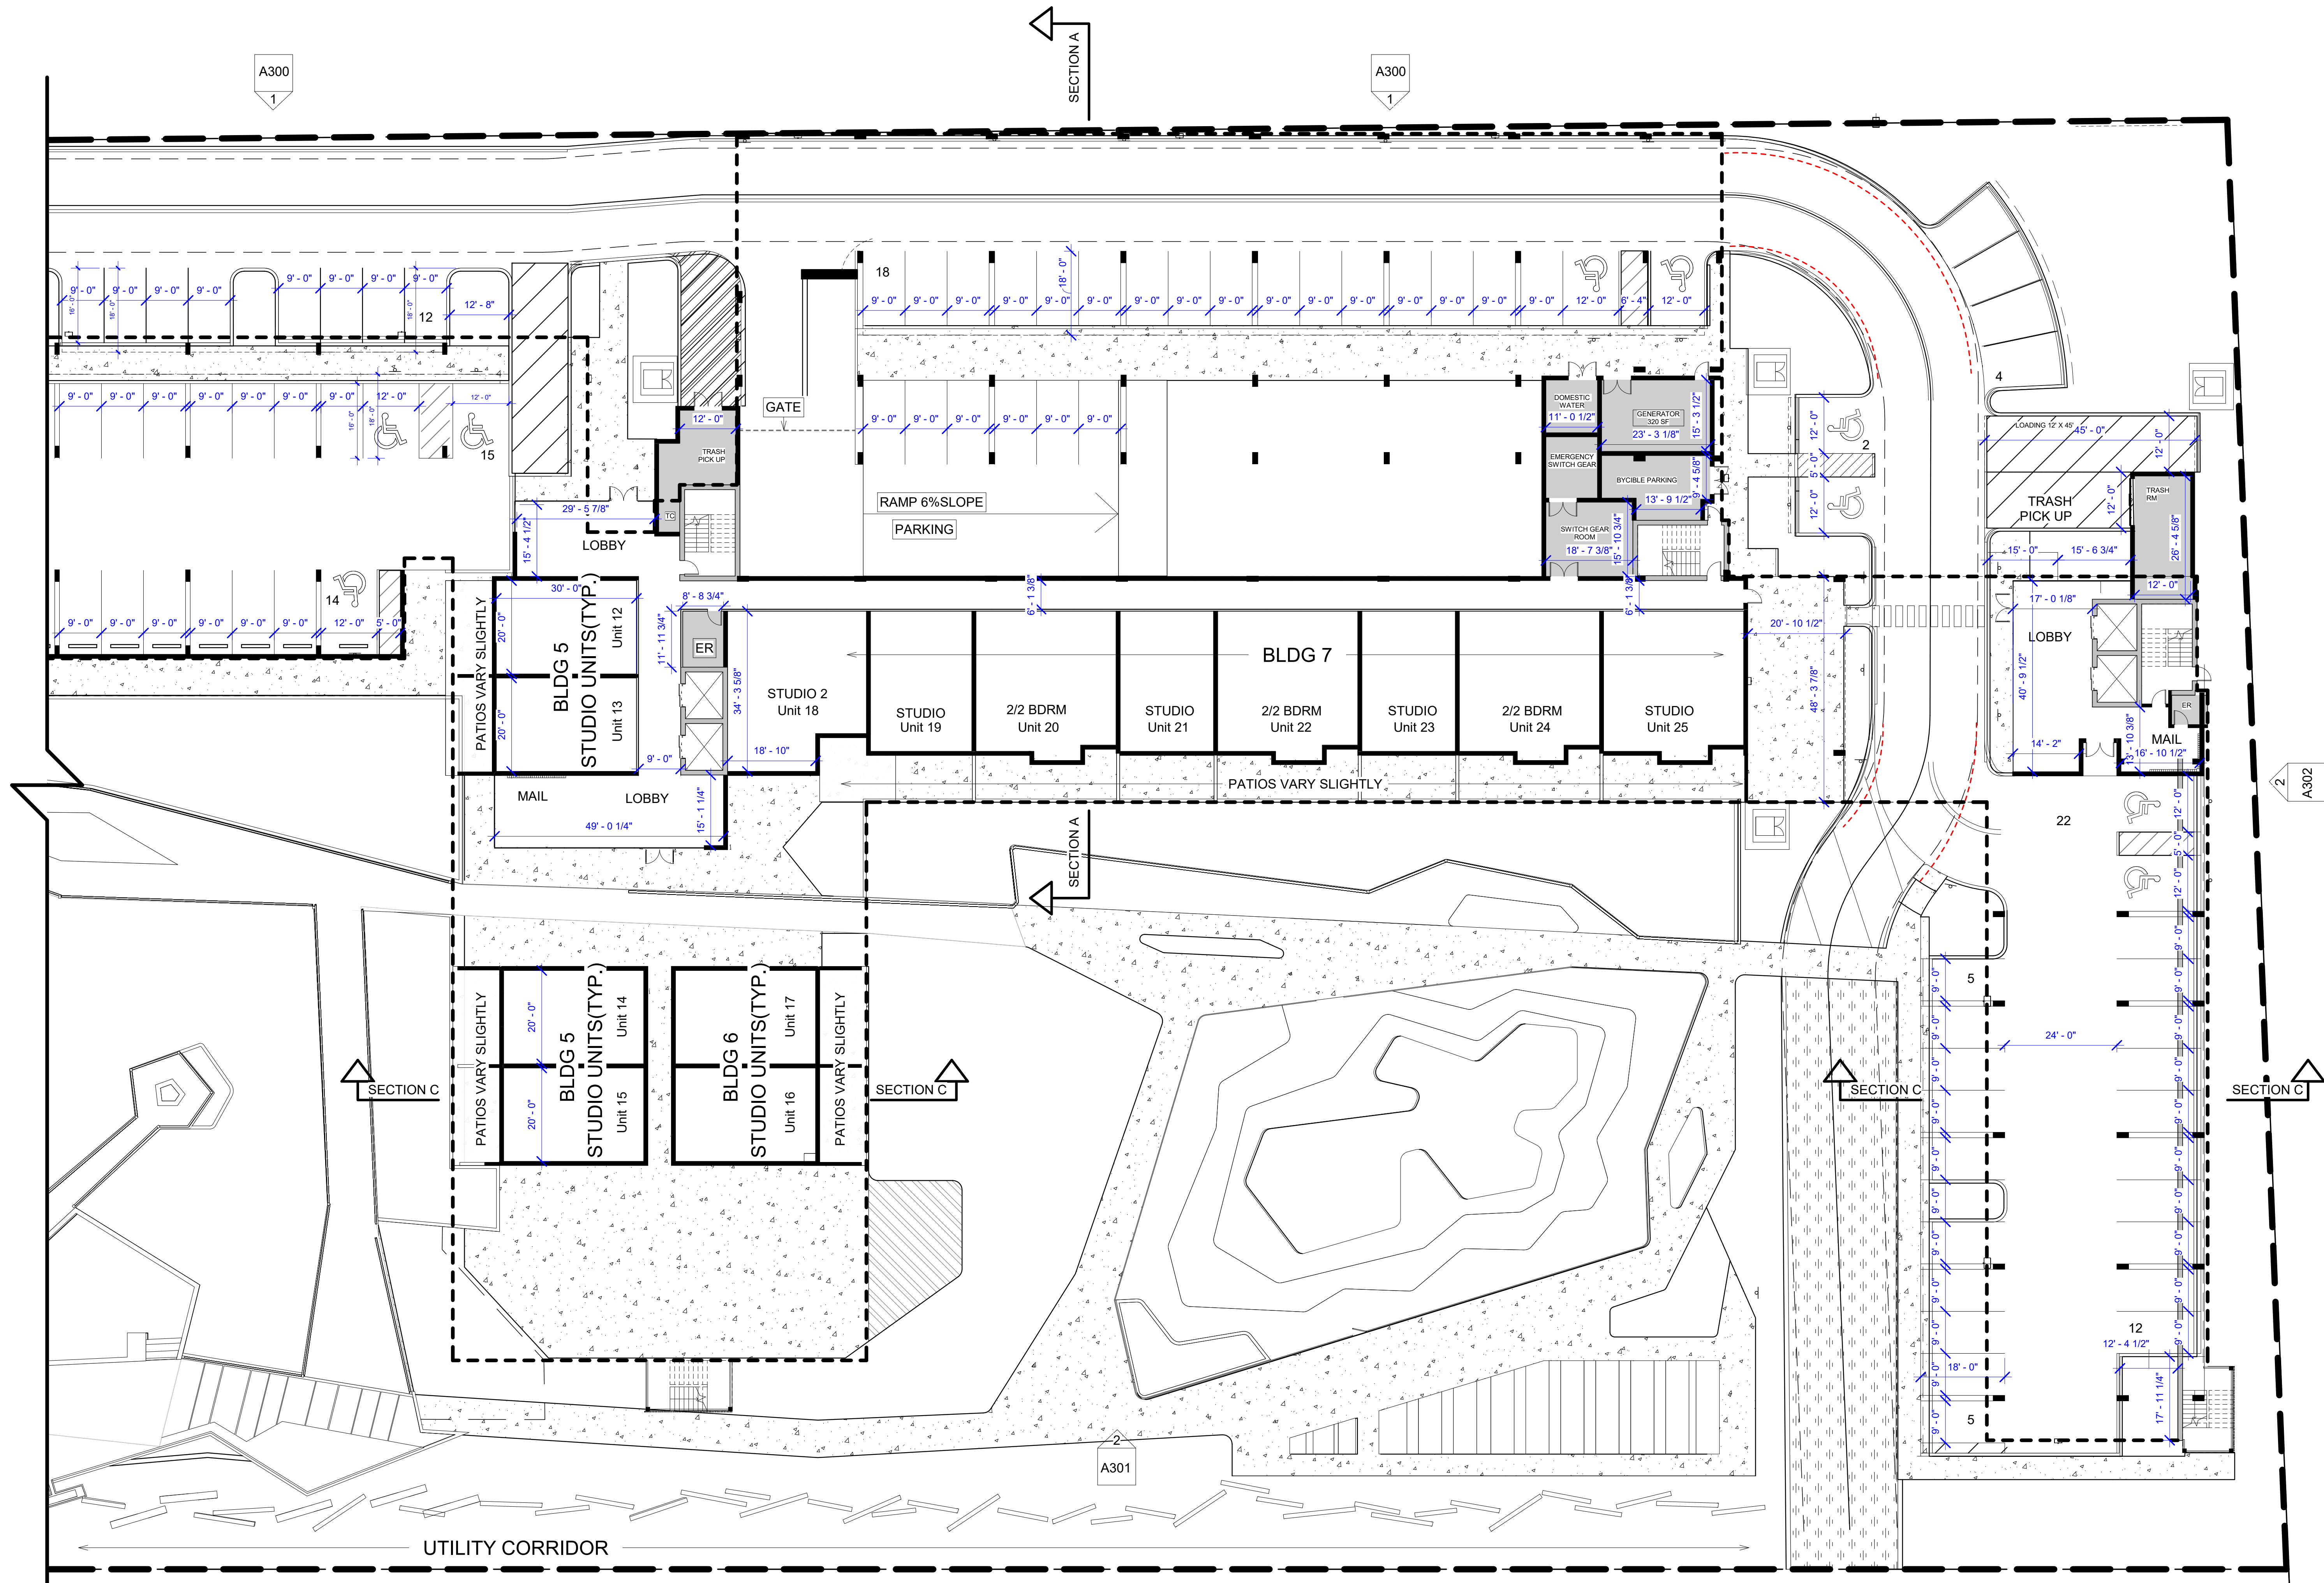

REVISIONS		4400 NW 8TH COURT, PLANTATION FL, 33317
1	DRC SUBMITTAL	06-25-18
2	PNZ SUBMITTAL	07-18-18
3	CITY COUNCIL SUBMITTAL	03-06-19

GROUND LEVEL / BLDG
5, 6, 7, 8 / EAST GROUND
LEVEL GARAGE

PROJECT
ADDRESS
PIXL
SHEET
DESCRIPTION

ARCHITECT OF
RECORD
H.L.S. DESIGN
ASSOCIATES INC. A/C
001185
10710 NW 80 CIRCLE
PARKLAND, FL 33076
HARRY MUNOZ - R.A.
AR - 12033

MAR-6-19
DATE
DRAWN
N.R.
CHECKED
C.L.

JOB # 7901

A102



PIXL

INVESCA
DEVELOPER

REVISIONS

NO.	DESCRIPTION	DATE
1	DRC SUBMITTAL	06-25-18
2	PNZ SUBMITTAL	07-18-18
3	CITY COUNCIL SUBMITTAL	03-06-19

4400 NW 8TH COURT,
PLANTATION FL, 33317

PROJECT
ADDRESS

ARCHITECT OF
RECORD

H.L.S. DESIGN
ASSOCIATES INC. A.A.C.
001185
10710 NW 80 CIRCLE
PARKLAND, FL 33076

MAR-6-19

DATE

JOB #

N.R.

DRAWN

CHECKED


C.L

RESIDENTIAL LEVEL 2
/BLDG 1,2,3,4 / WEST
GARAGE LEVEL 2

SHEET
DESCRIPTION

HARRY MUNOZ - R.A.
AR - 12033

A103

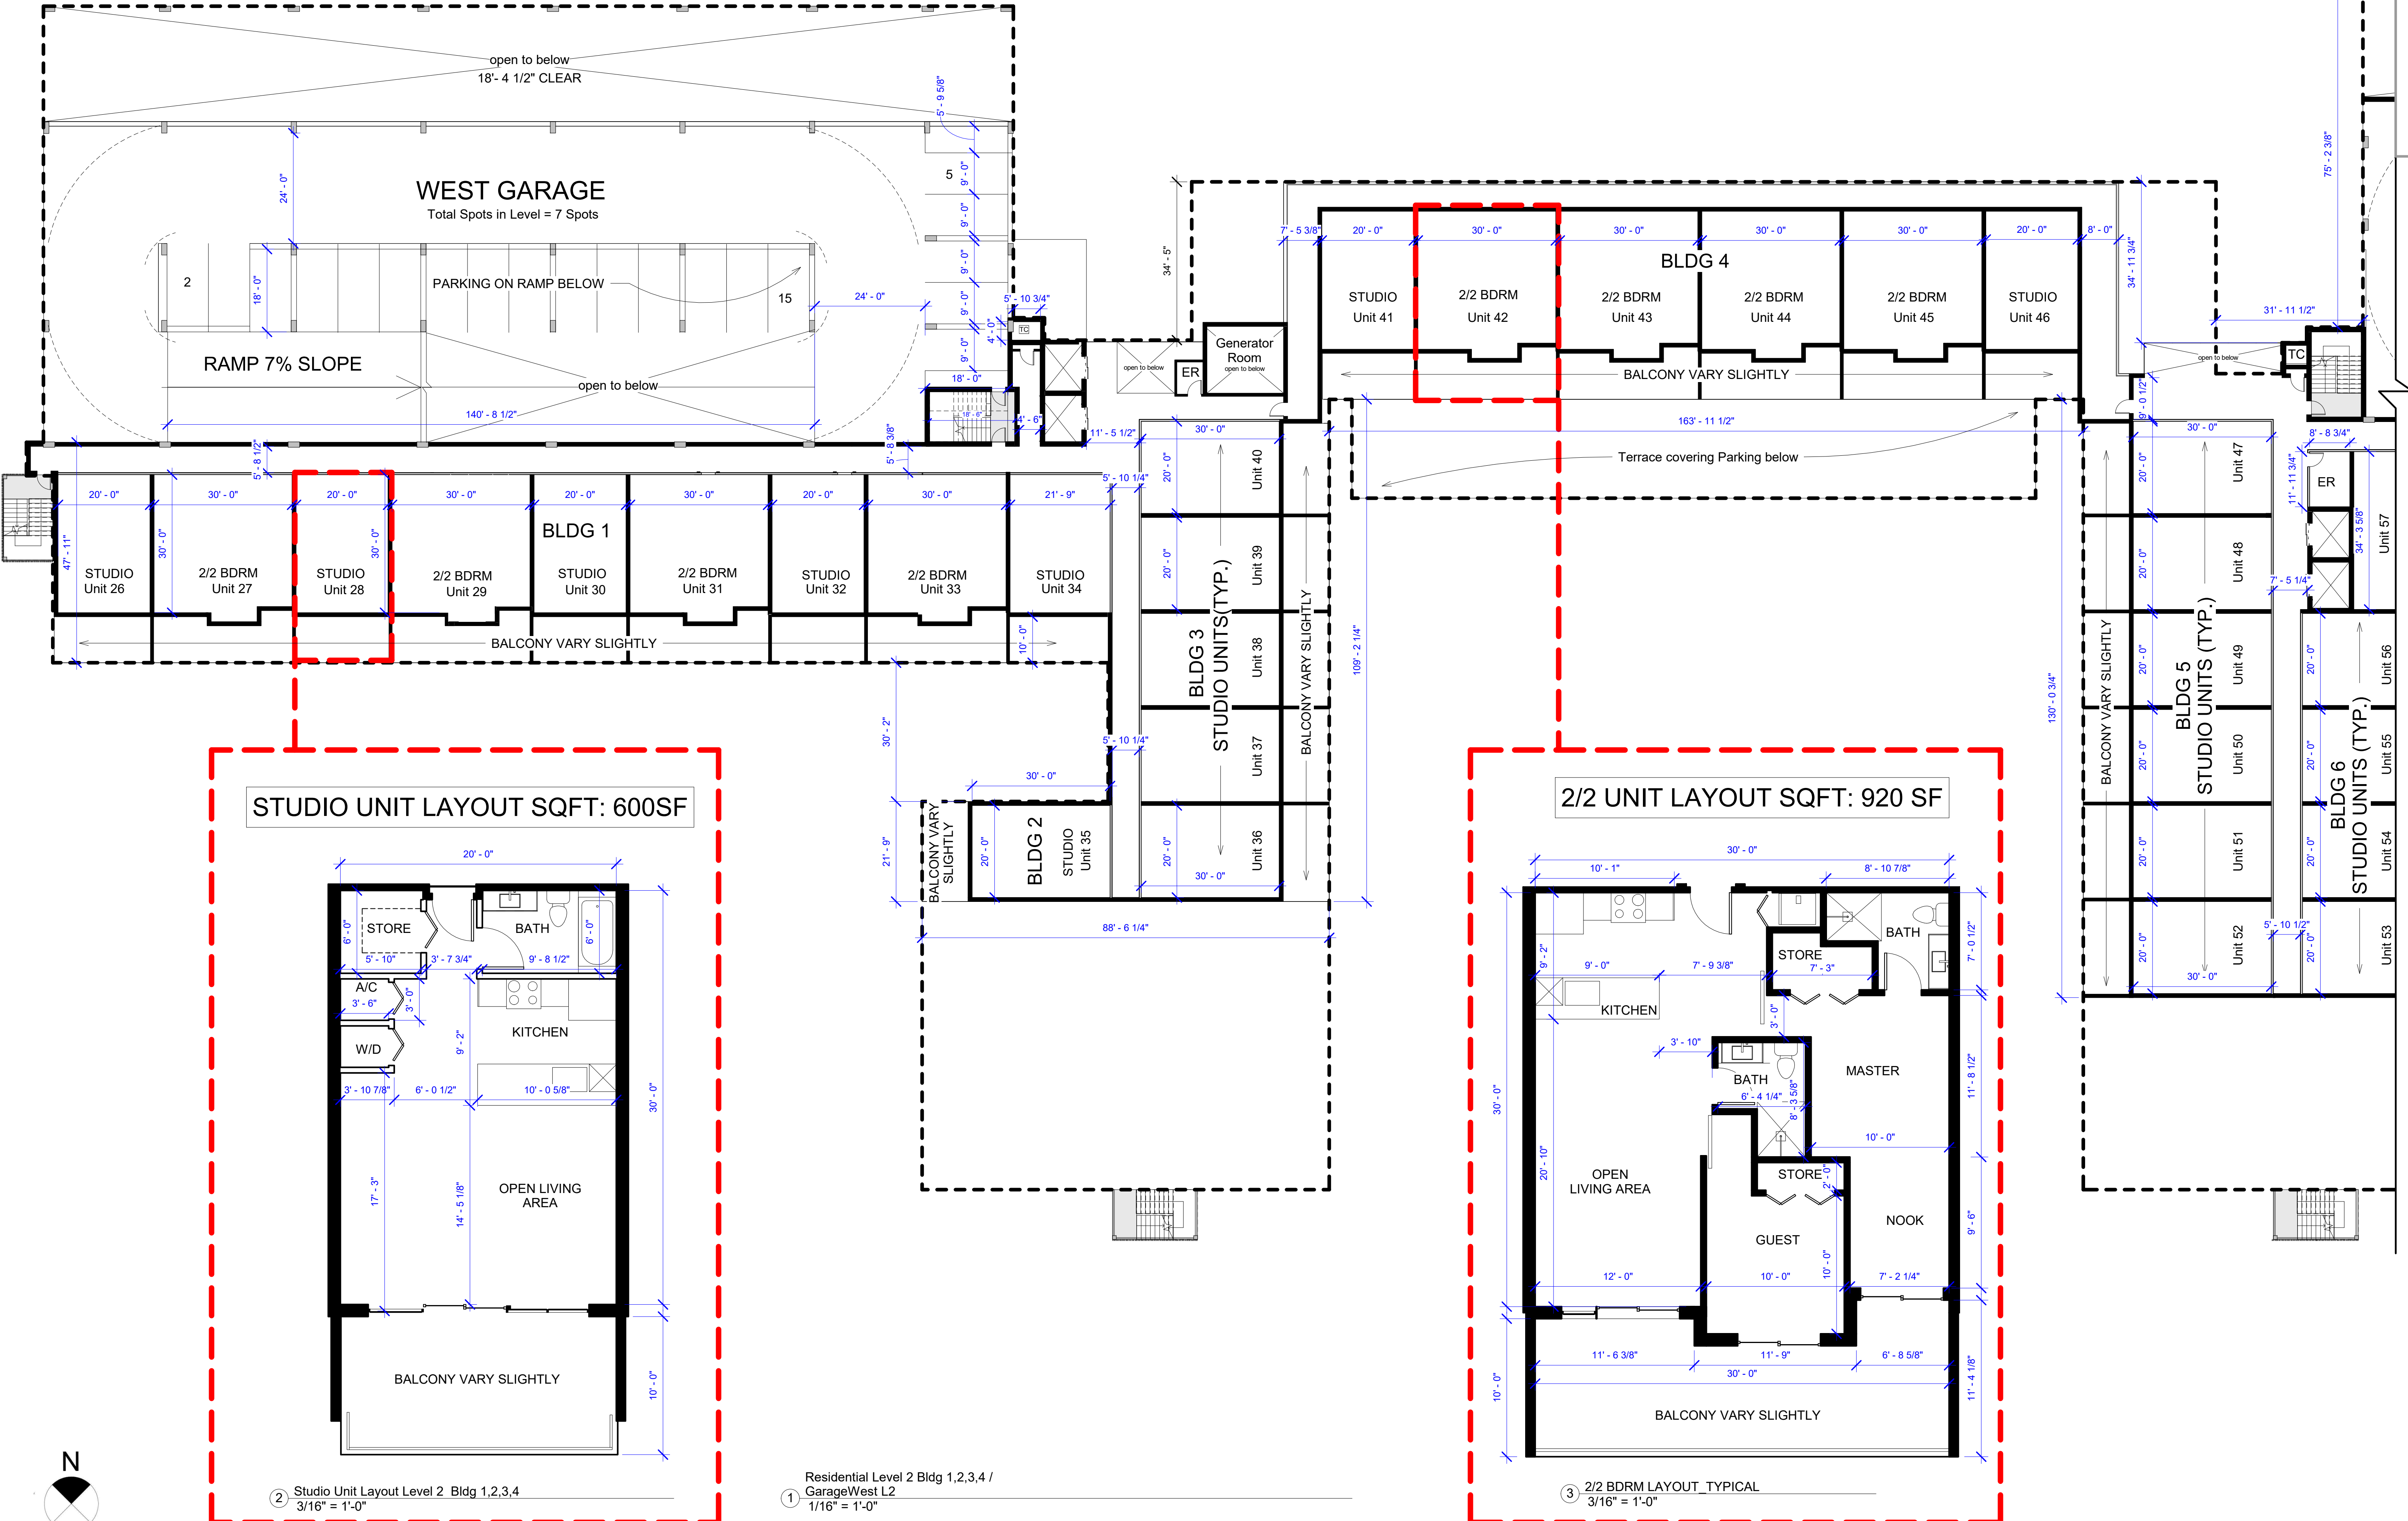



STUDIO UNIT LAYOUT SQFT: 600SF

② Studio Unit Layout Level 2 Bldg 1,2,3,4
3/16" = 1'-0"

① Residential Level 2 Bldg 1,2,3,4 /
GarageWest L2
1/16" = 1'-0"

2/2 UNIT LAYOUT SQFT: 920 SF

 ③ 2/2 BDRM LAYOUT TYPICAL
3/16" = 1'-0"

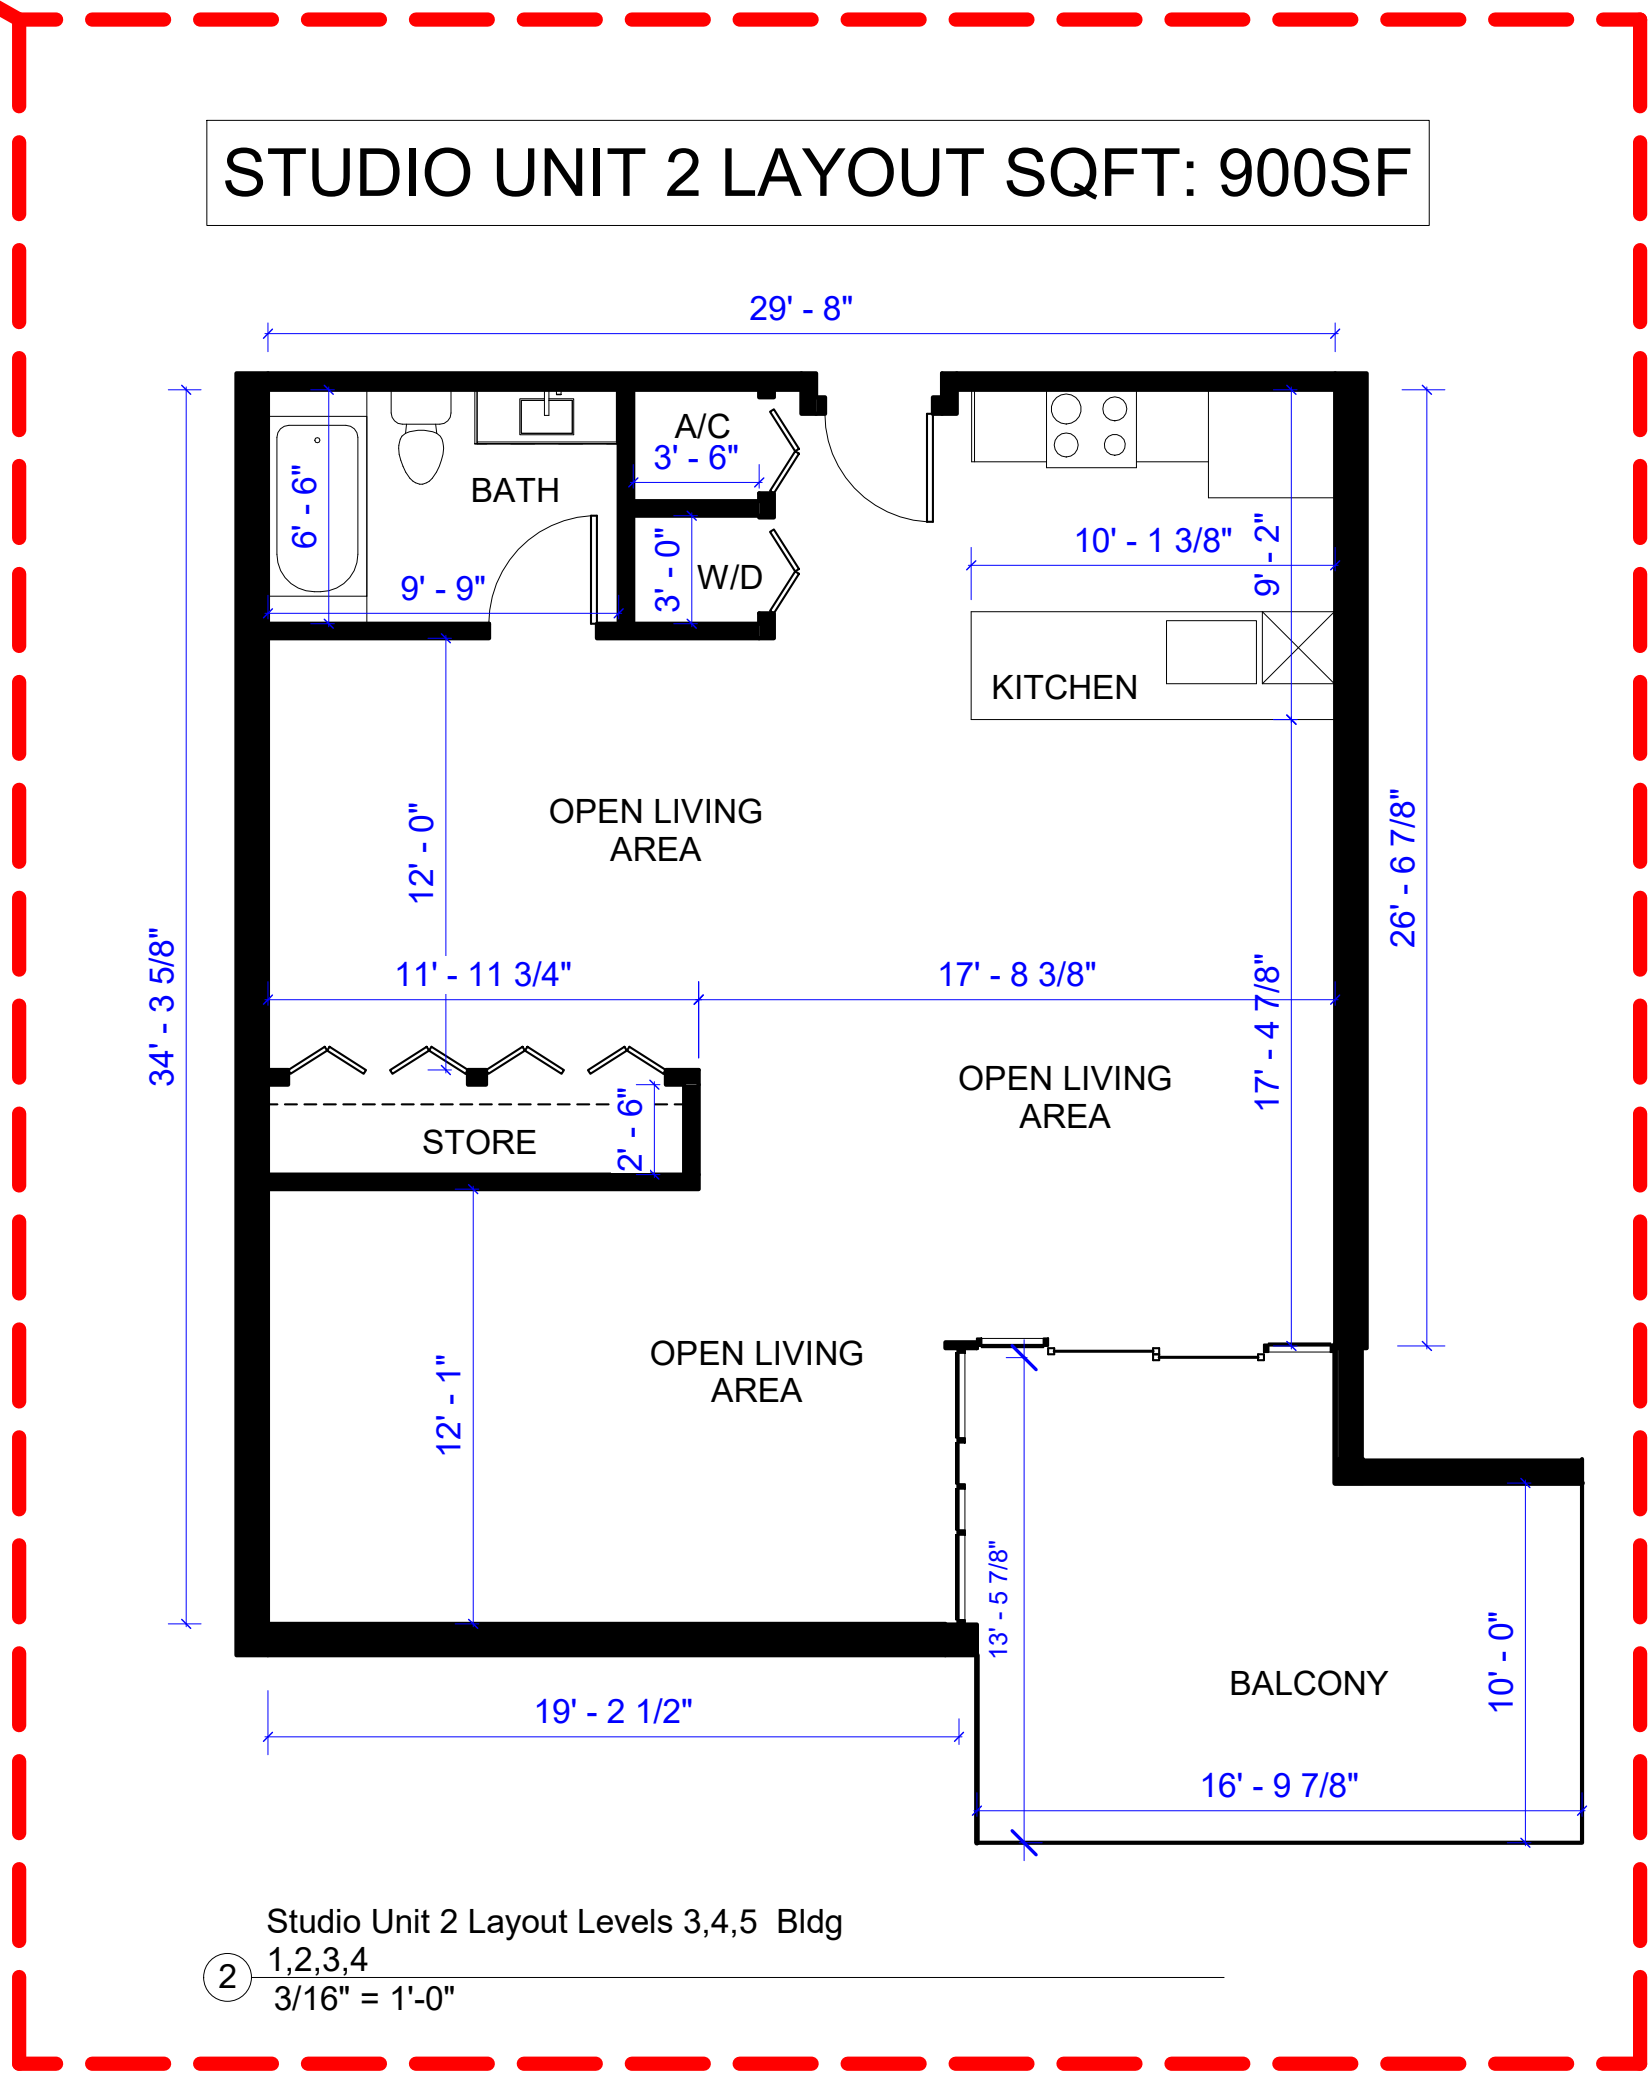

Studio Unit 2 Layout Levels 3,4,5 Bldg
 ② 1,2,3,4
 3/16" = 1'-0"



P I X L

INVESTSCA
DEVELOPMENT

REVISIONS		
1	DRC SUBMITTAL	06-25-18
2	PNZ SUBMITTAL	07-18-18
3	CITY COUNCIL SUBMITTAL 03-06-19	

400 NW 8TH COURT,
LANTATION FL, 33317

RESIDENTIAL LEVEL 2
/BLDG 5,6,7,8 / EAST
04.3.05.05.05.05.05.05.

PROJECT ADDRESS	PIXL	SHEET DESCRIPTION
-----------------	------	-------------------

ARCHITECT OF
RECORD

H.L.S. DESIGN
ASSOCIATES INC. AAC
001185

10710 NW 80 CIRCLE
PARKLAND, FL 33076


HARRY MUNOZ - R.A
AR - 12033

MAR-6-19
N.R.
C I

DATE	DRAWN	CHECKED
------	-------	---------

JOB #	7901
-------	------

A104

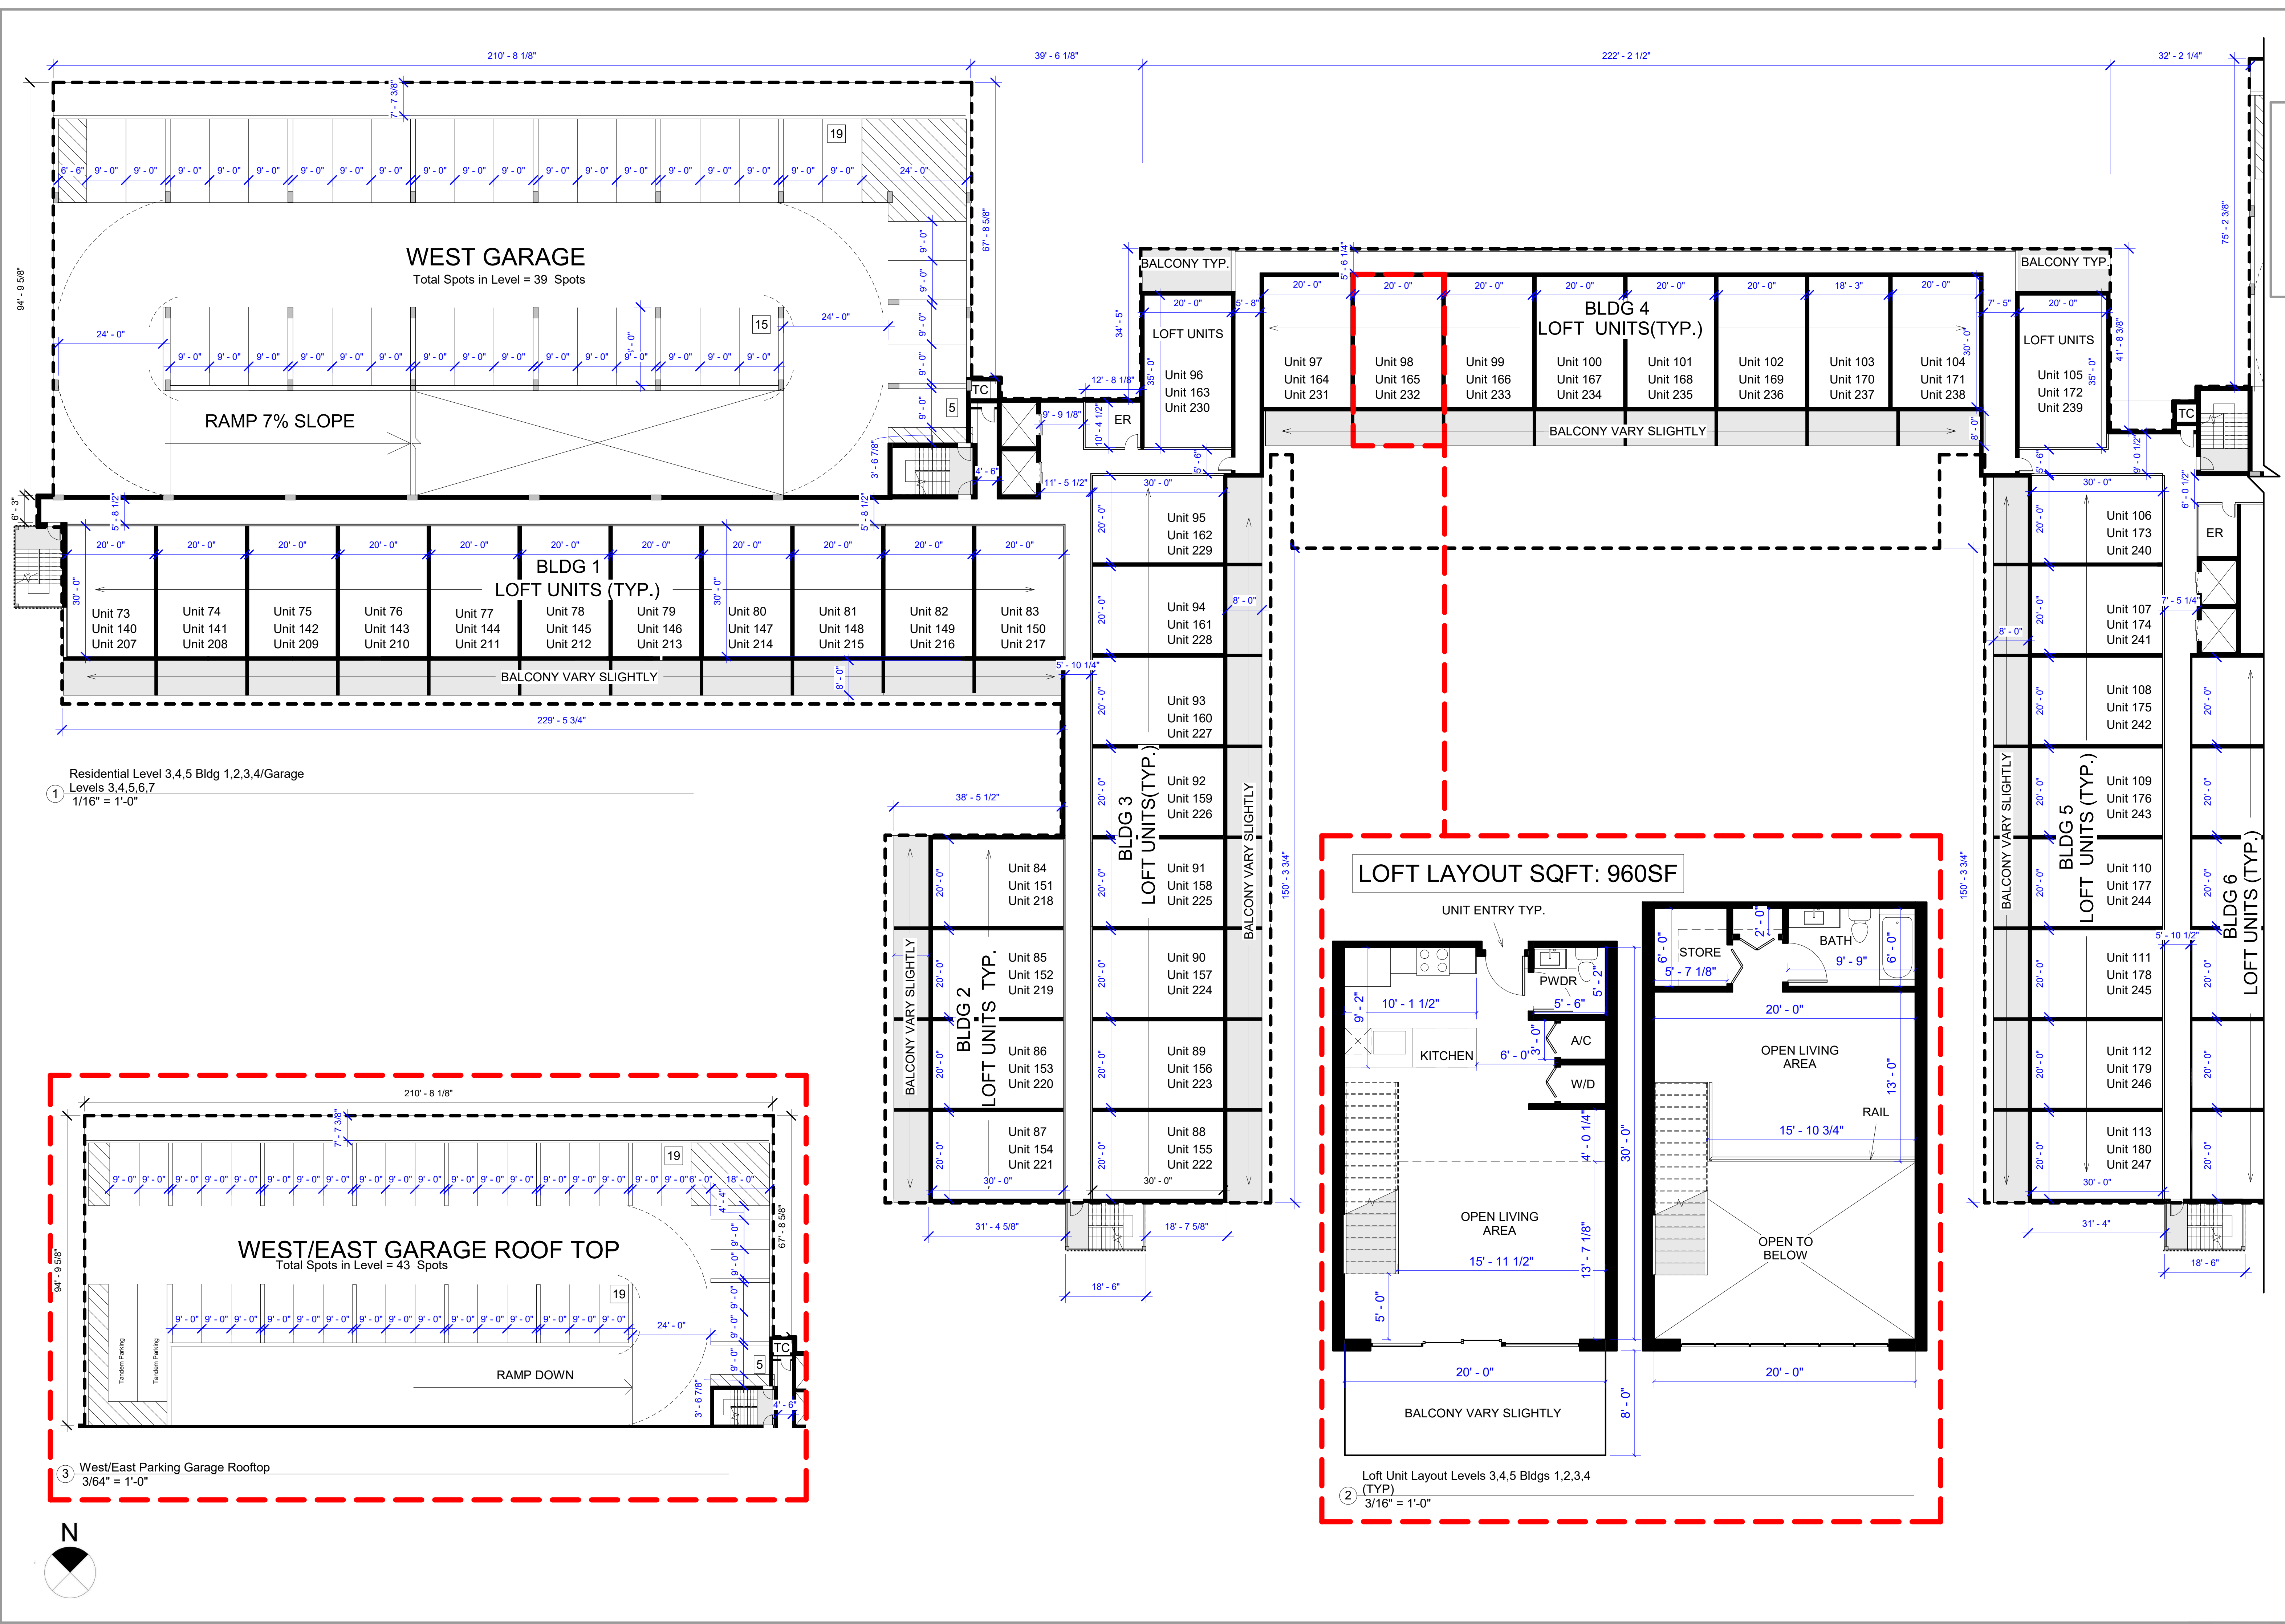

1 Residential Level 3,4,5 Bldg 1,2,3,4/Garage Levels 3,4,5,6,7
1/16" = 1'-0"

3 West/East Parking Garage Rooftop
3/64" = 1'-0"

2 Loft Unit Layout Levels 3,4,5 Bldgs 1,2,3,4 (TYP.)
3/16" = 1'-0"

REVISIONS		PROJECT ADDRESS	ARCHITECT OF RECORD	DATE	DRAWN	CHECKED
1	DRC SUBMITTAL	4400 NW 8TH COURT, PLANTATION FL, 33317	H.L.S. DESIGN ASSOCIATES INC. A.A.C. 001185	MAR-6-19	N.R.	C.L.
2	PNZ SUBMITTAL					
3	CITY COUNCIL SUBMITTAL					

DEVELOPER

RESIDENTIAL LEVEL 3,4,5 /BLDG 1,2,3,4 WEST GARAGE LEVEL 3,4,5,6,7, ROOFTOP

JOB # 7901

A105



PIXL

INVESCA

REVISIONS

NO.	DESCRIPTION	DATE
1	DRC SUBMITTAL	06-25-18
2	PNZ SUBMITTAL	07-18-18
3	CITY COUNCIL SUBMITTAL	03-06-19

4400 NW 8TH COURT,
PLANTATION FL, 33317

PROJECT
ADDRESS

ARCHITECT OF
RECORD

H.L.S. DESIGN
ASSOCIATES INC. A/C
001185
10710 NW 80 CIRCLE
PARKLAND, FL 33076

MAR-6-19

DATE

JOB #

A106

N.R.


DRAWN

CHECKED

C.L

SHEET
DESCRIPTION


RESIDENTIAL LEVEL 3,4,5
_BLDG 5,6,7,8 / EAST
GARAGE LEVEL 3,4,5,6,7

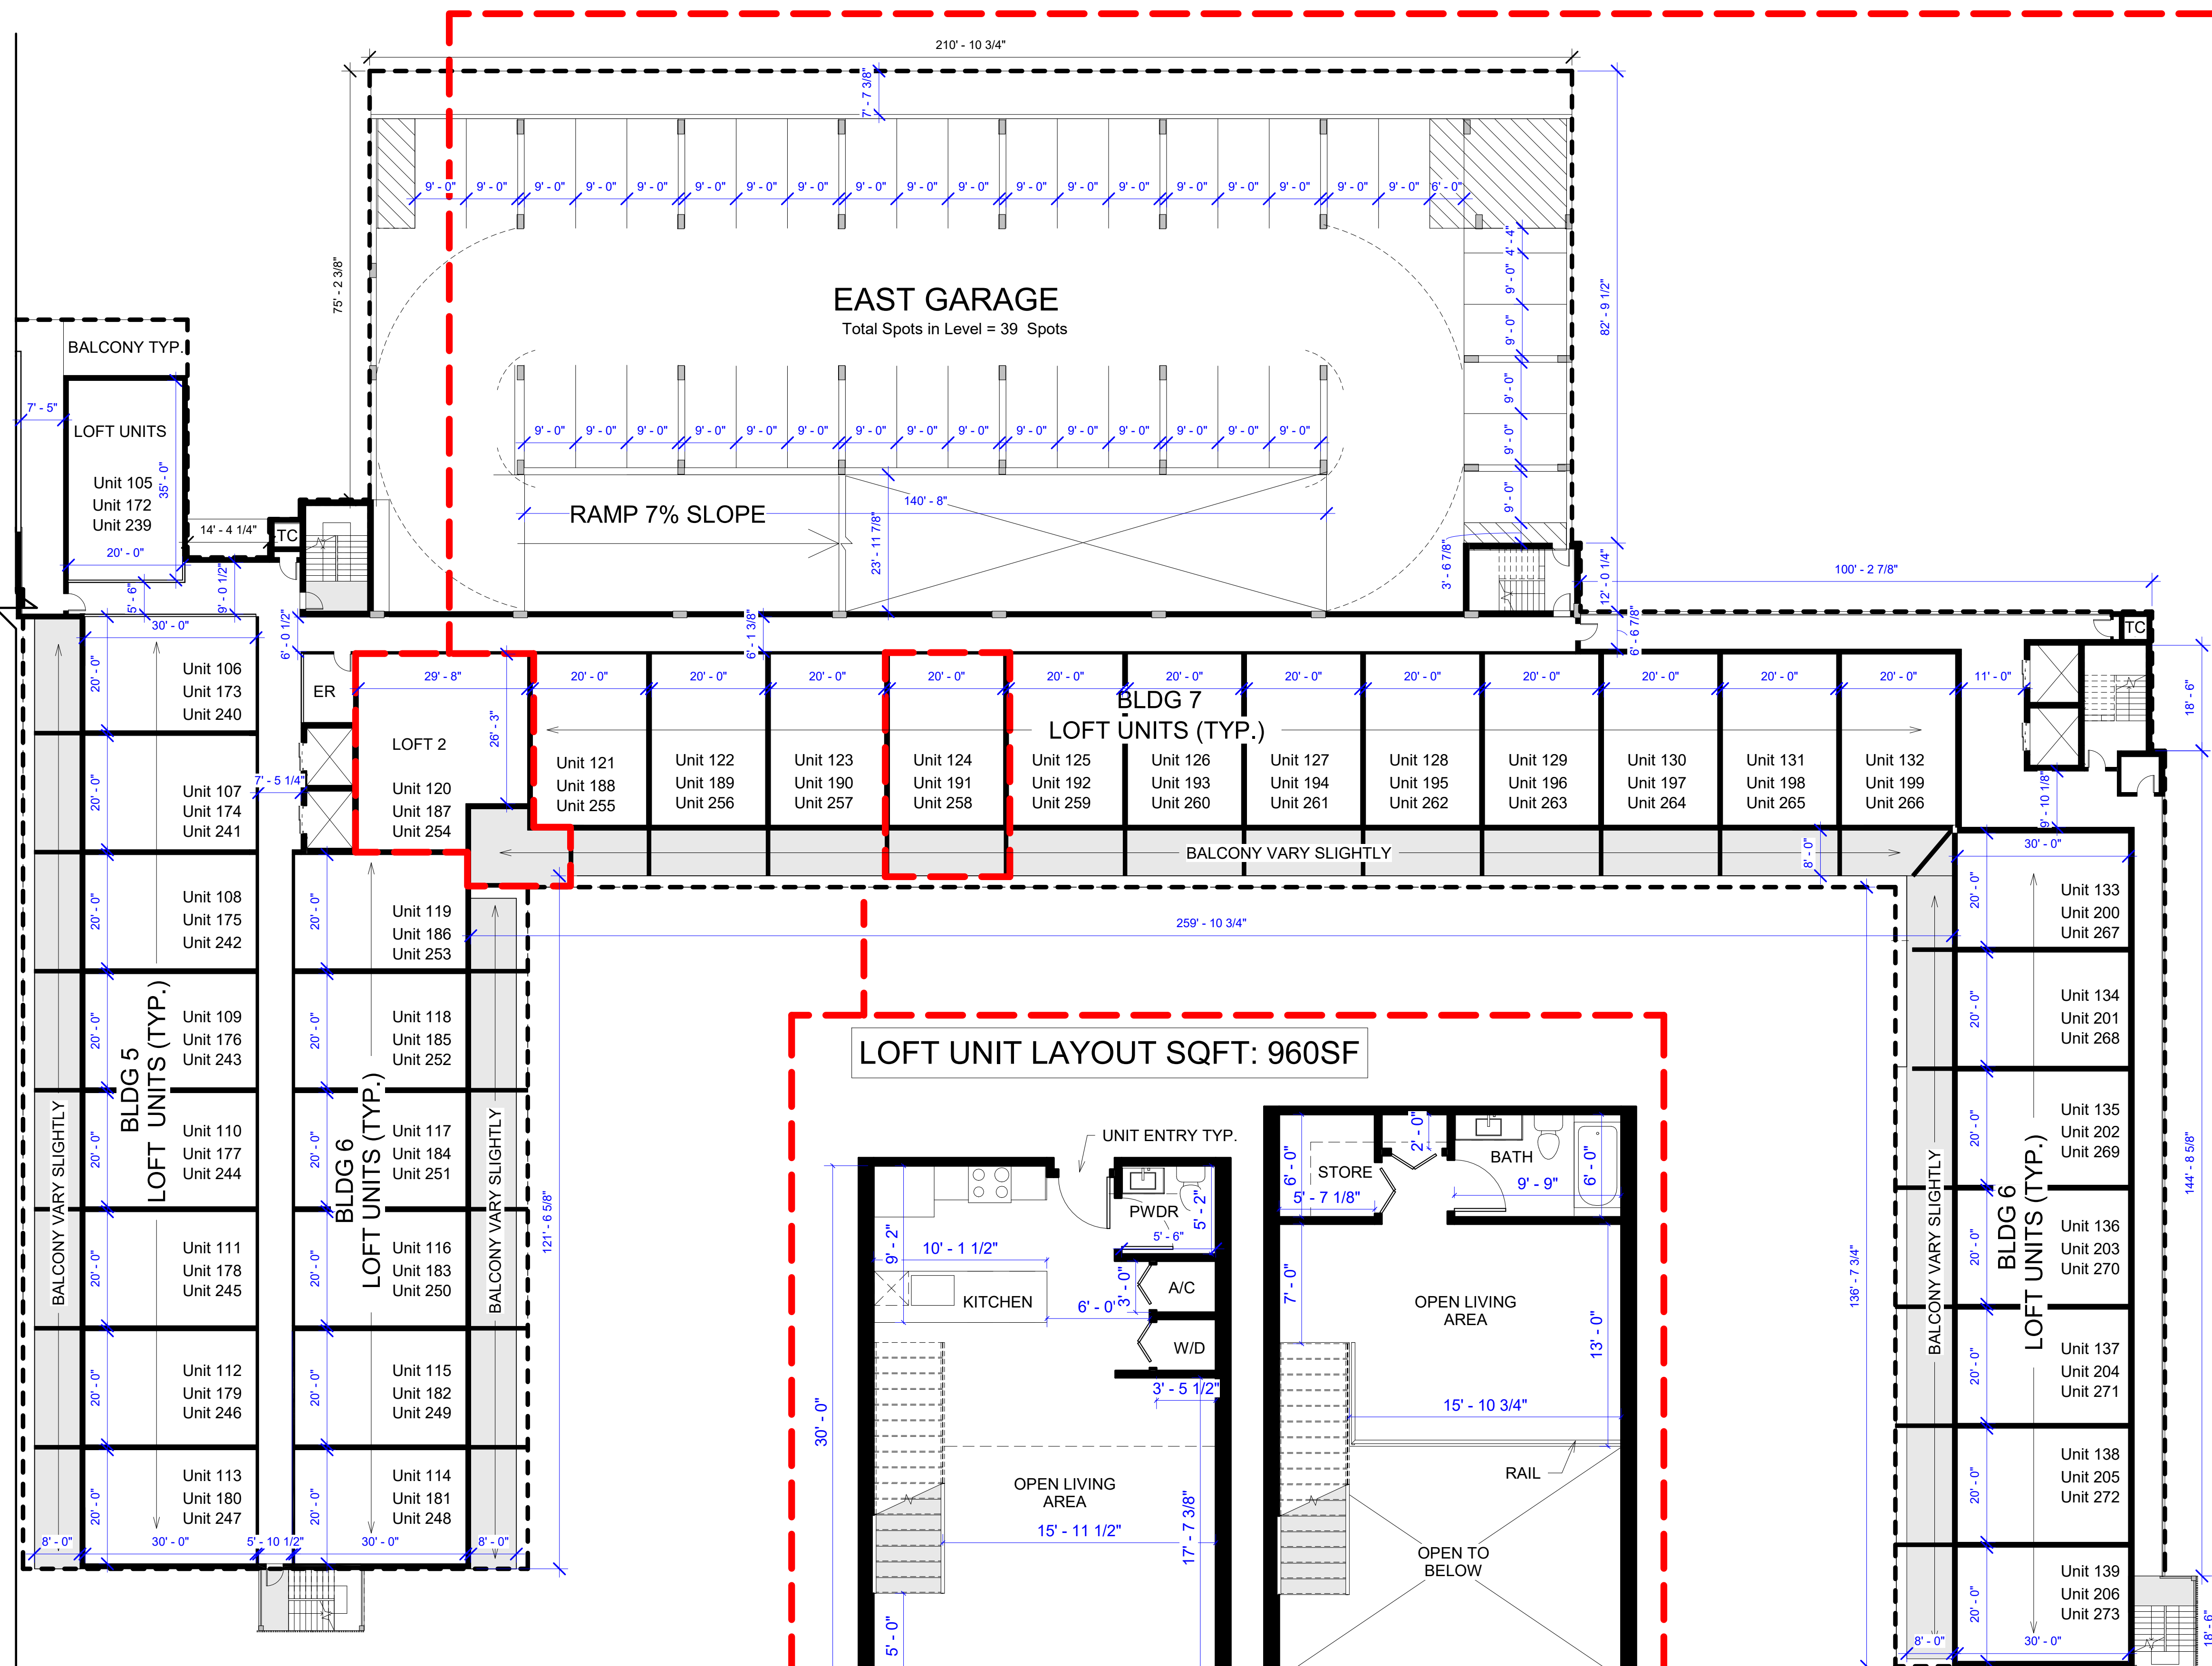

LOFT UNIT LAYOUT SQFT: 960SF

Loft Unit Layout Levels 3,4,5_Bldg 5,6,7,8
(TYP)
3/16" = 1'-0"



LOFT 2 UNIT LAYOUT SQFT: 1350 SF

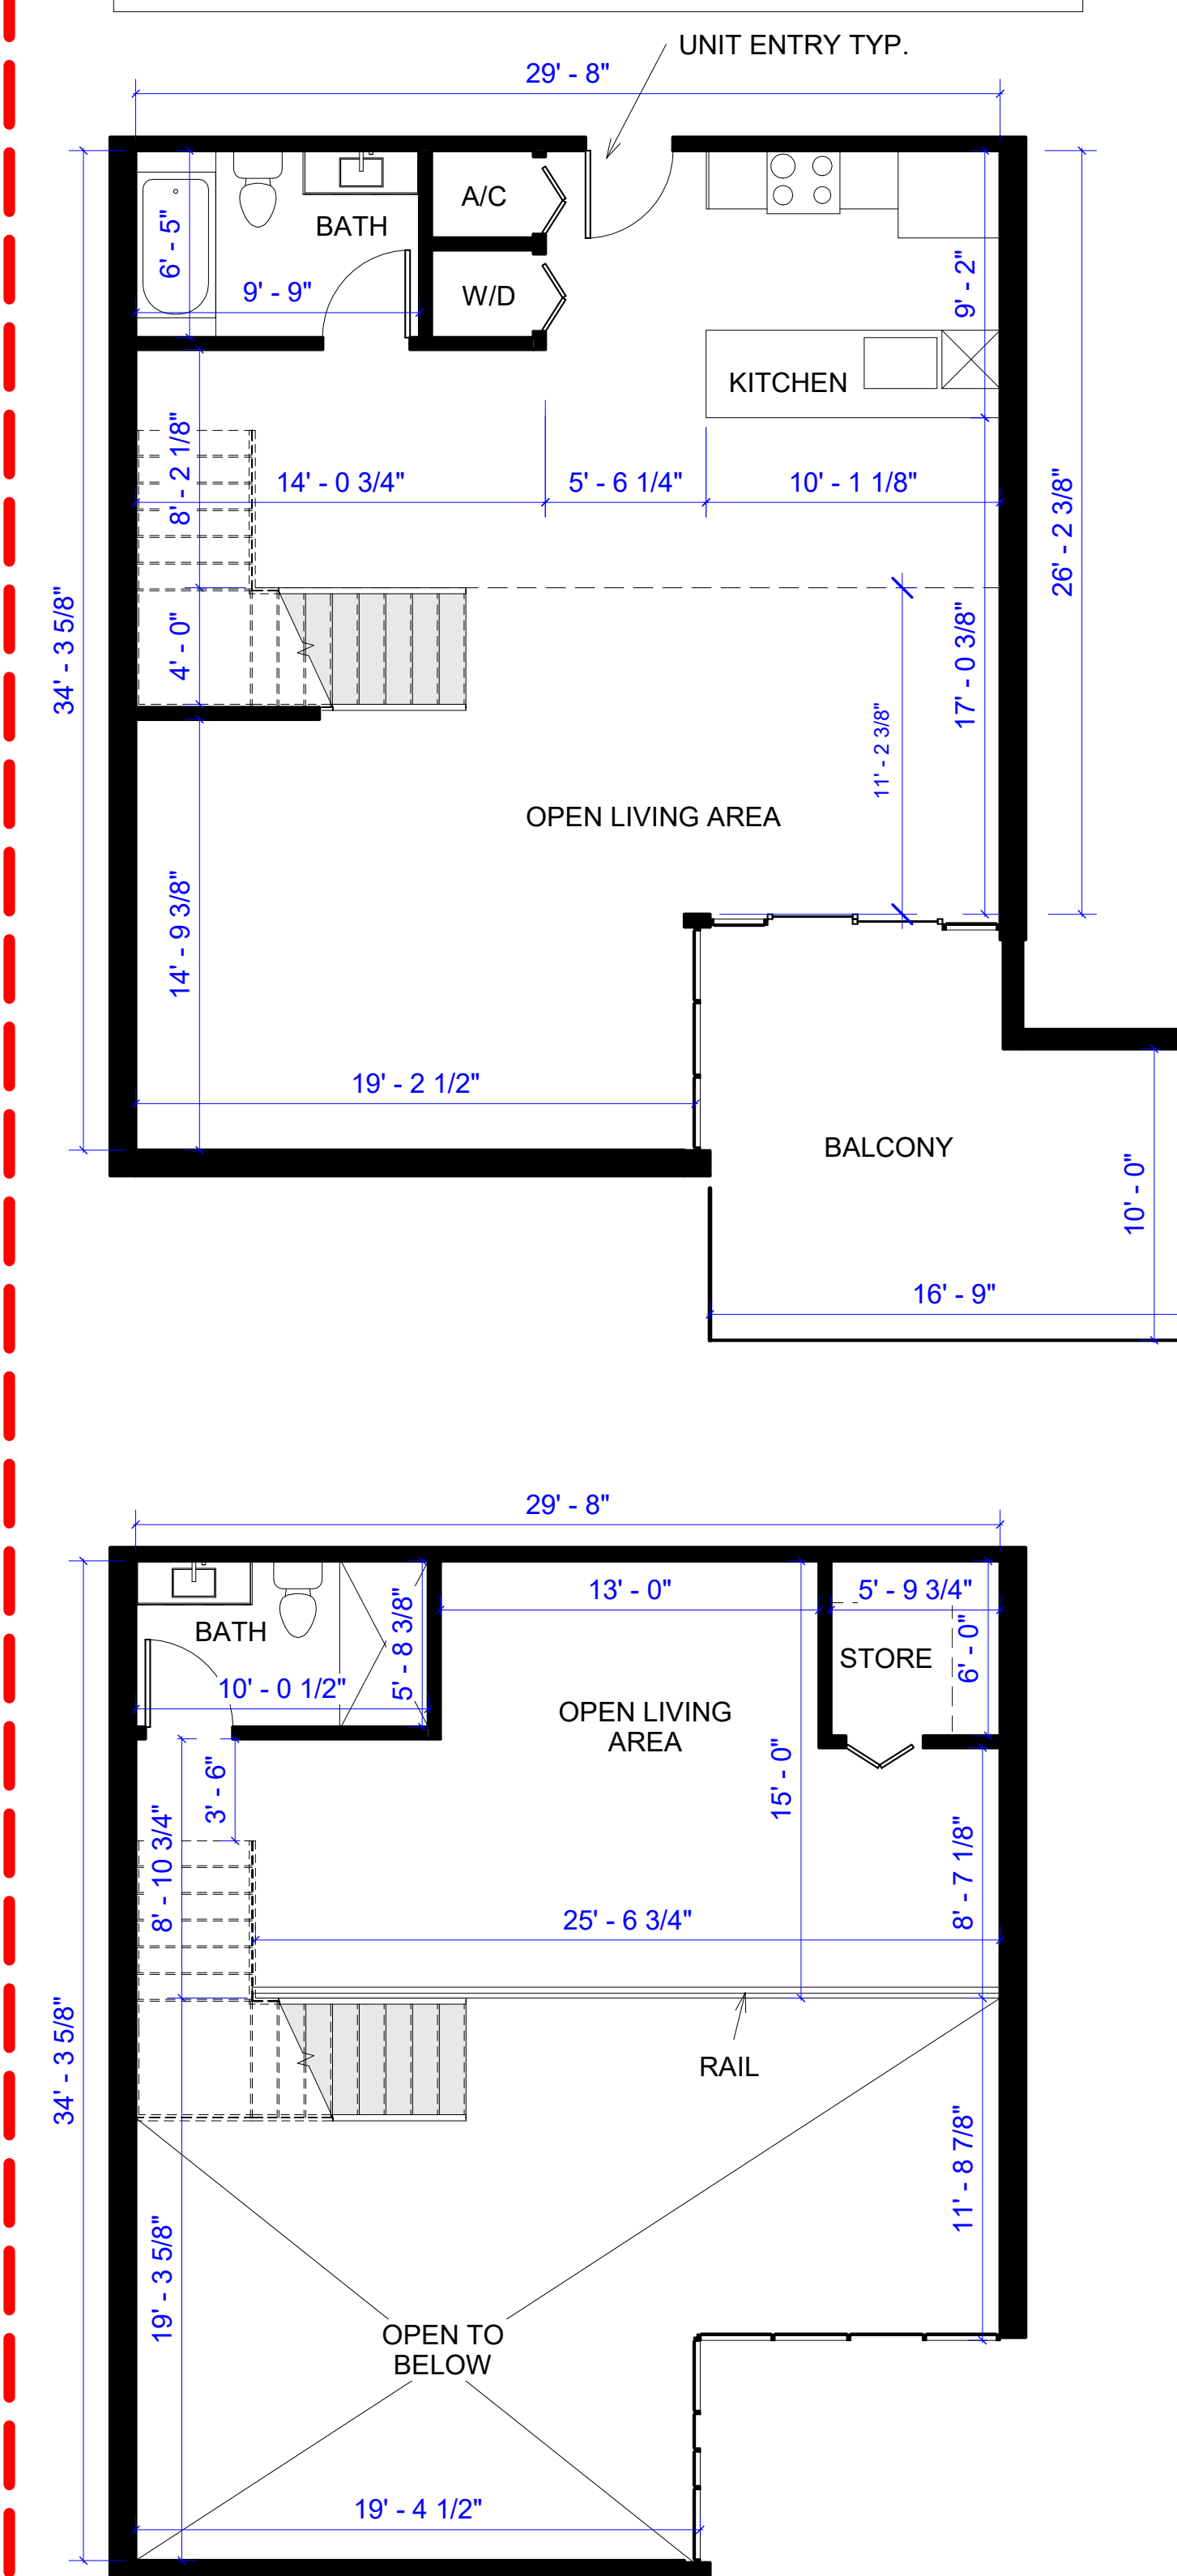

Loft Unit 2 Layout Levels 3,4,5_Bldg 5,6,7,8
3/16" = 1'-0"

Residential Level 3,4,5 Bldg 5,6,7,8/Garage
Levels 3,4,5,6,7
1/16" = 1'-0"



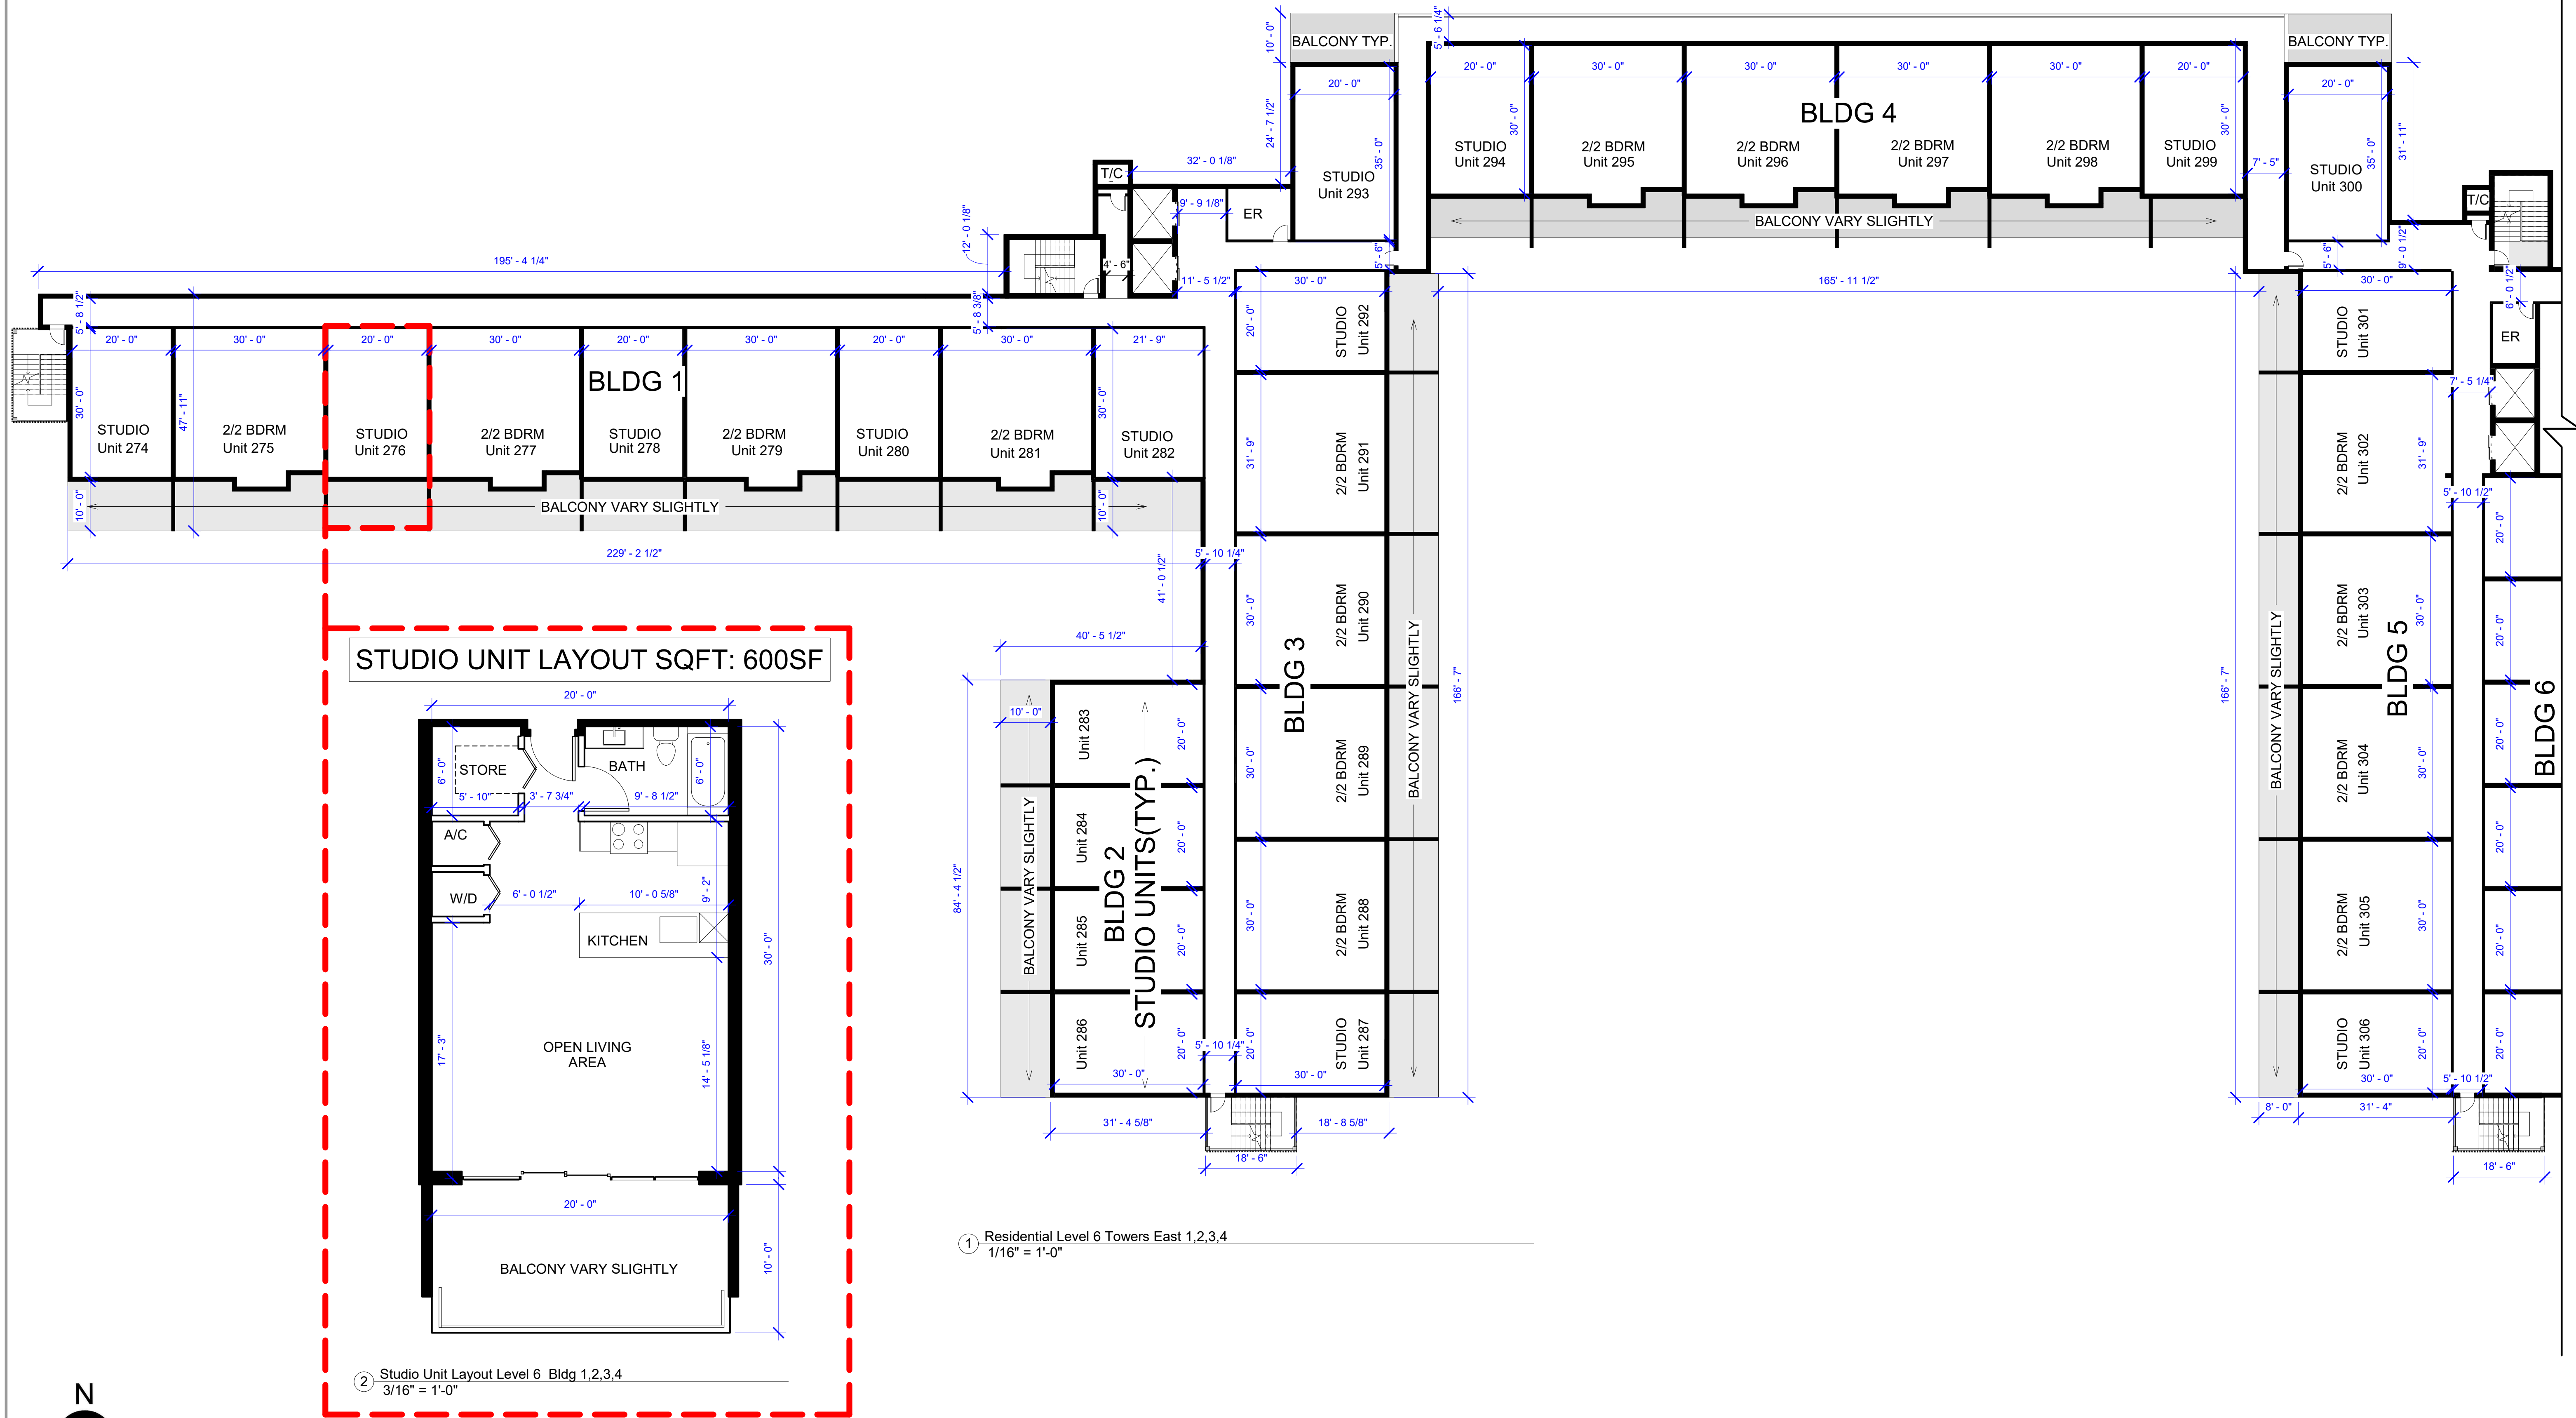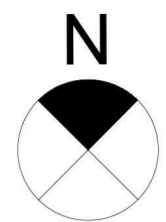

P I X L

INVESCA
DEVELOPER

REVISIONS

1 DRC SUBMITTAL 06-25-18

2 PNZ SUBMITTAL 07-18-18

3 CITY COUNCIL SUBMITTAL 03-06-19

4400 NW 8TH COURT,
PLANTATION FL, 33317

PIXL

SHEET
DESCRIPTION

ARCHITECT OF
RECORD

H.L.S. DESIGN
ASSOCIATES INC. AAC
001185
10710 NW 80 CIRCLE
PARKLAND, FL 33076

HARRY MUNOZ - R.A
AR - 12033

MAR-6-19

N.R.

C.L

DATE


DRAWN

CHECKED

JOB #


7901

A107

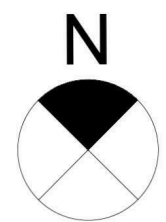


1 Residential Level 6 Towers East 5,6,7,8
1/16" = 1'-0"

2 Studio Unit 2 Layout Levels 6
3/16" = 1'-0"


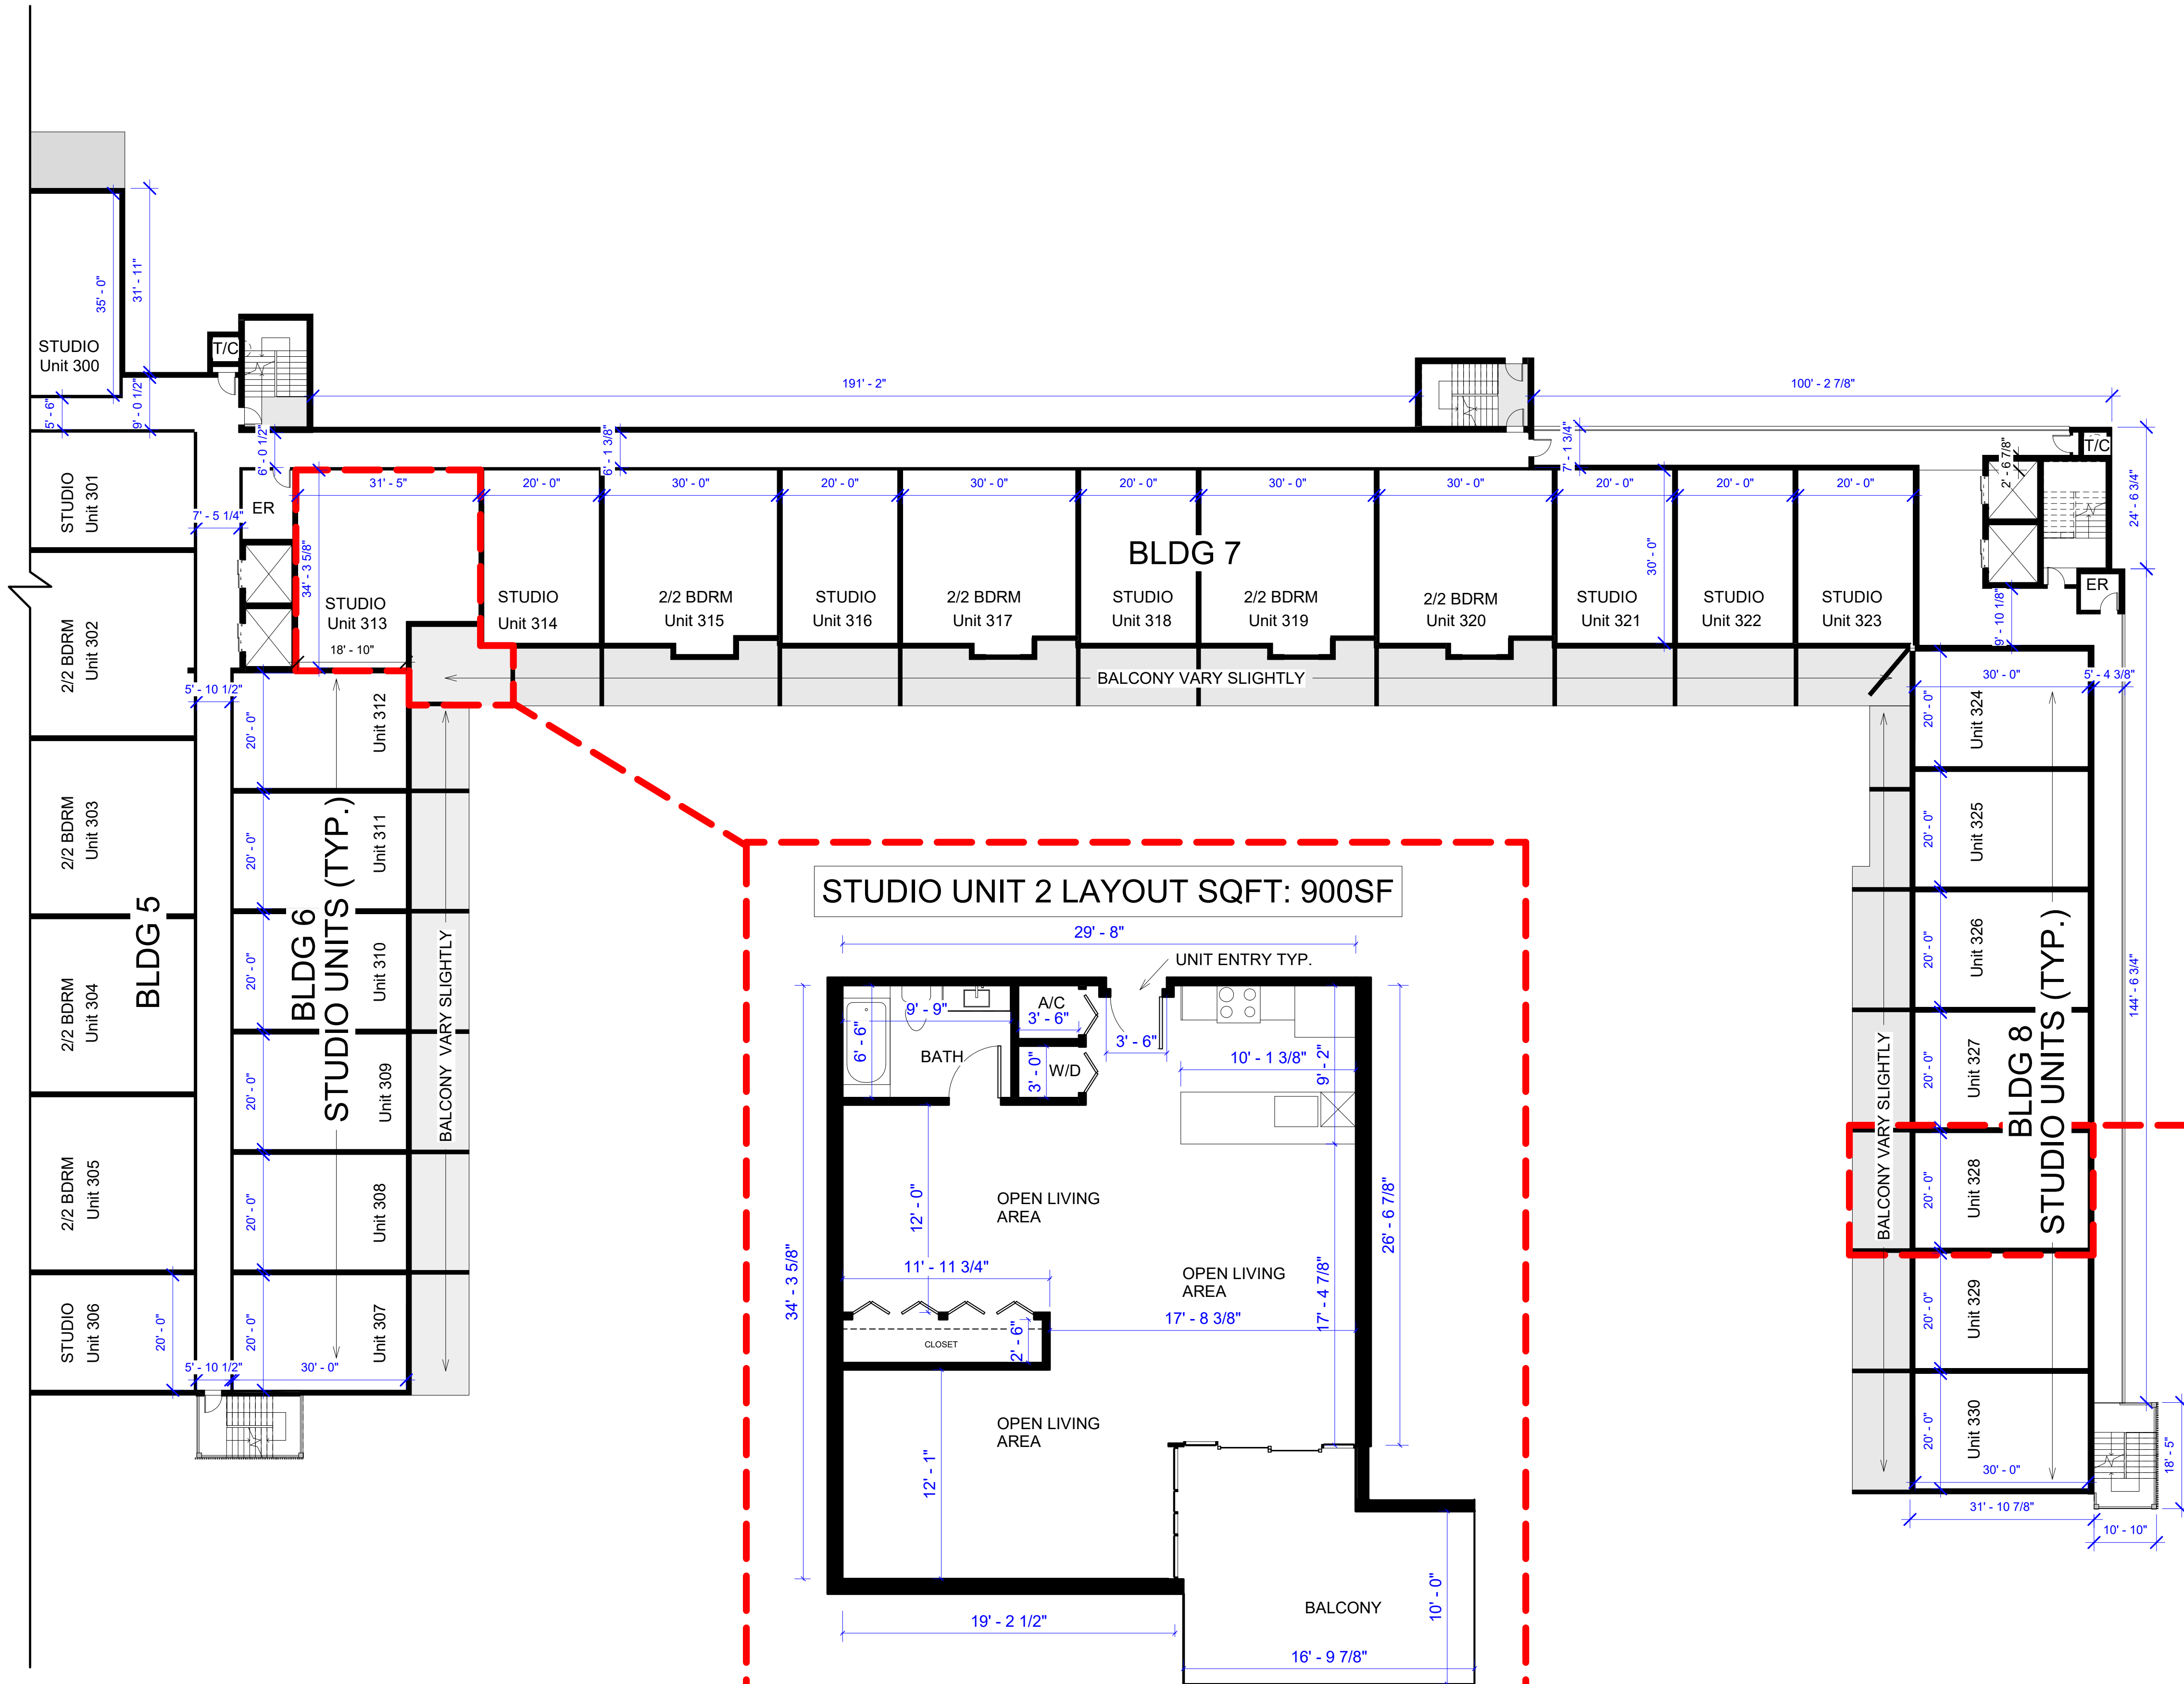


STUDIO UNIT LAYOUT SQFT: 600SF

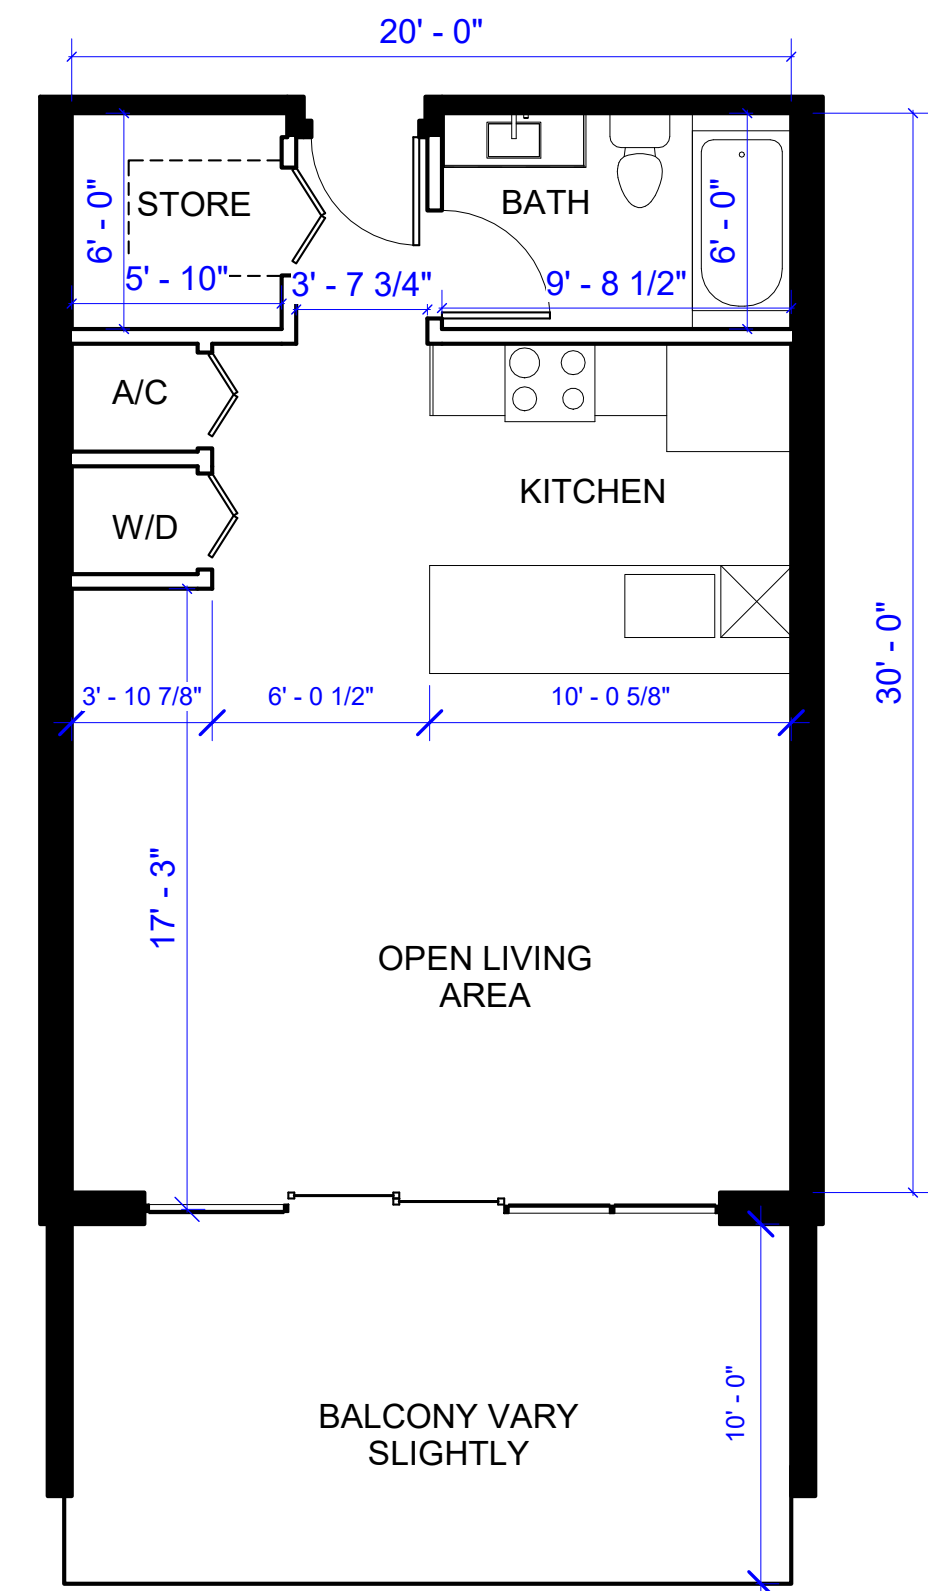

3 Studio Unit Layout Level 6 Bldg5,6,7,8
3/16" = 1'-0"

STUDIO UNIT 2 LAYOUT SQFT: 900SF

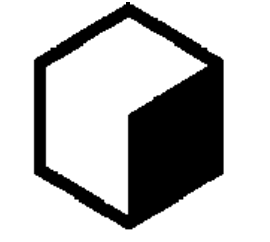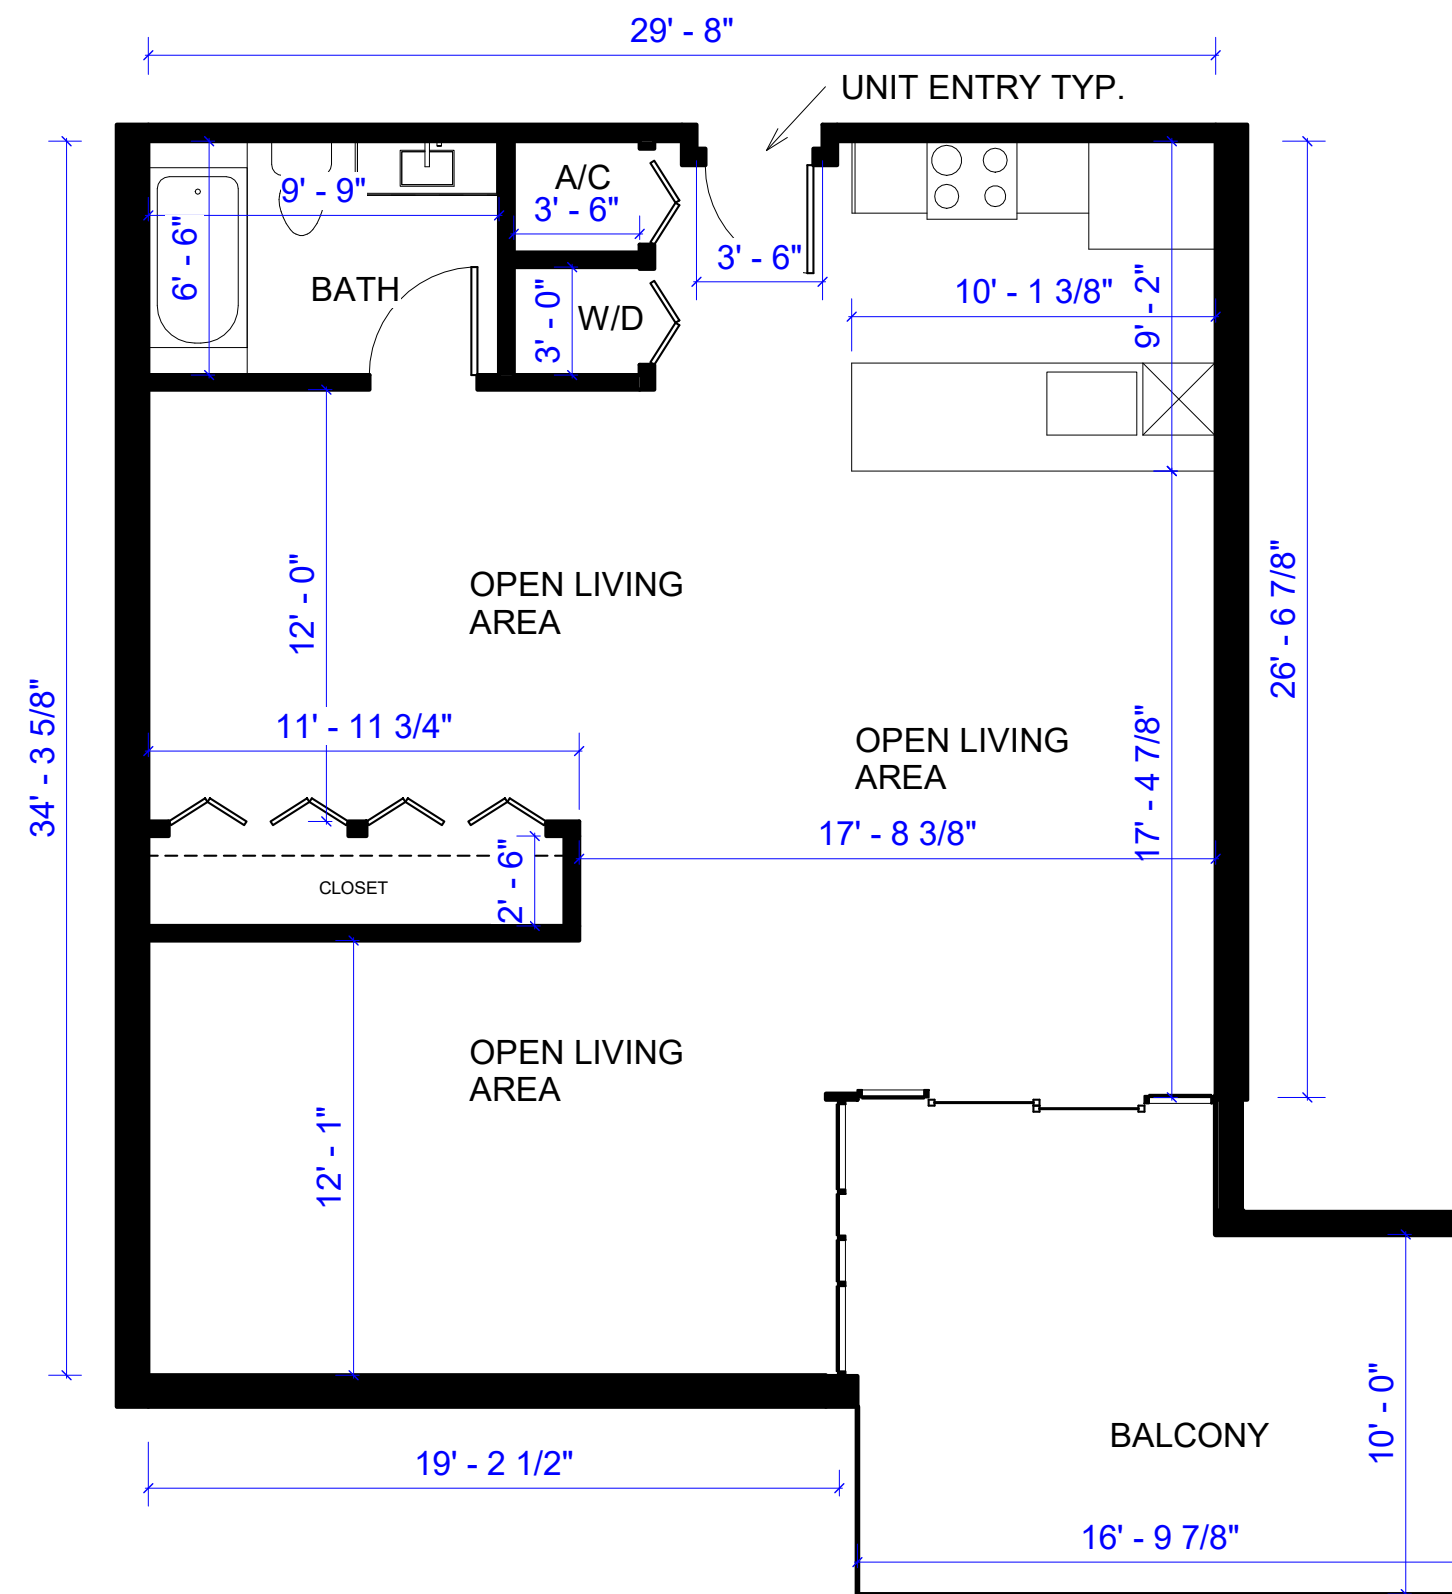

P I X L

INVESCA
DEVELOPER

REVISIONS		DATE	DESCRIPTION
1	DRC SUBMITTAL	06-25-18	
2	PNZ SUBMITTAL	07-18-18	
3	CITY COUNCIL SUBMITTAL	03-06-19	

4400 NW 8TH COURT,
PLANTATION FL, 33317
RESIDENTIAL LEVEL 6
/BLDG 5,6,7,8/NO
PARKING

PROJECT
ADDRESS
PIXL
SHEET
DESCRIPTION

ARCHITECT OF
RECORD
H.L.S. DESIGN
ASSOCIATES INC. A/C
001185
10710 NW 80 CIRCLE
PARKLAND, FL 33076

HARRY MUNOZ - R.A.
AR - 12033

MAR-6-19
DATE
N.R.
DRAWN
C.L.
CHECKED

JOB # 7901

A108




REVISIONS		
1	DRC SUBMITTAL	06-25-18
2	PNZ SUBMITTAL	07-18-18
3	CITY COUNCIL SUBMITTAL 03-06-19	


PROJECT ADDRESS	PIXL	SHEET DESCRIPTION
-----------------	------	-------------------


HARRY MUNOZ - R.A
AR - 12033

DRAWN
CHECKED


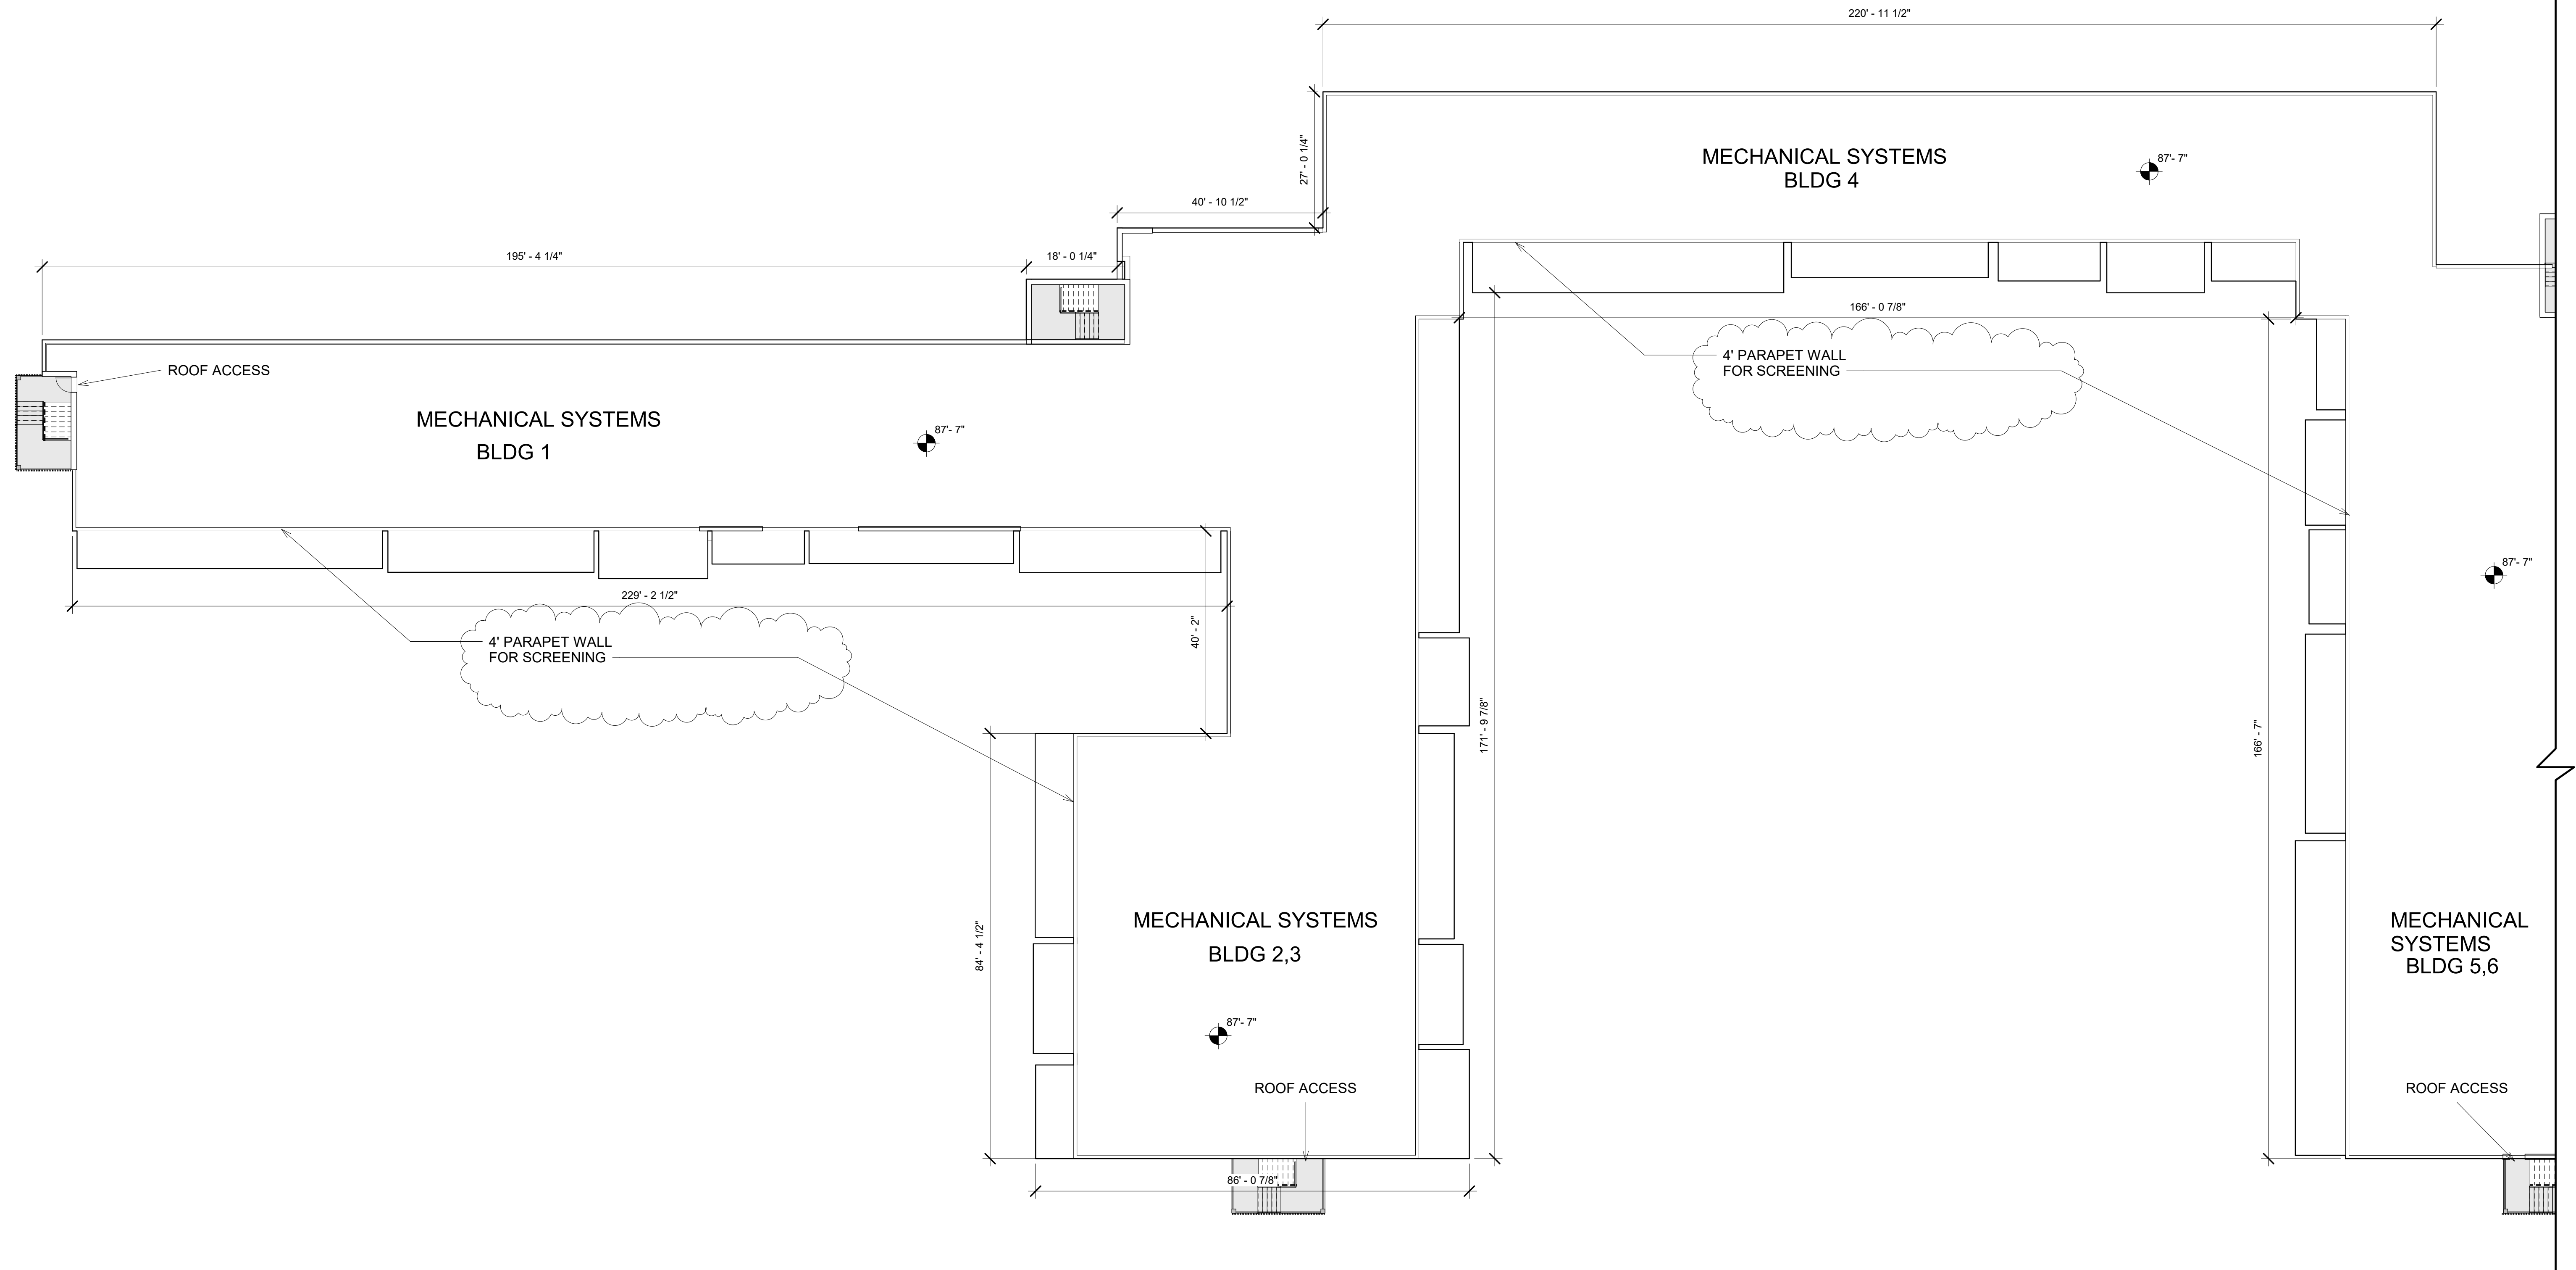
A109

① Roof Plan Bldg 1,2,3,4
1/16" = 1'-0"

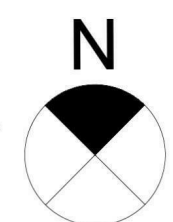


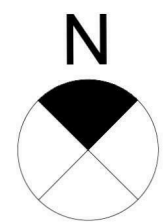

1 Roof Plan Bldg 5,6,7,8
1/16" = 1'-0"

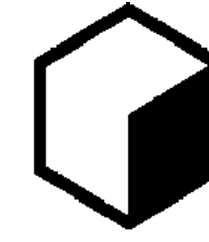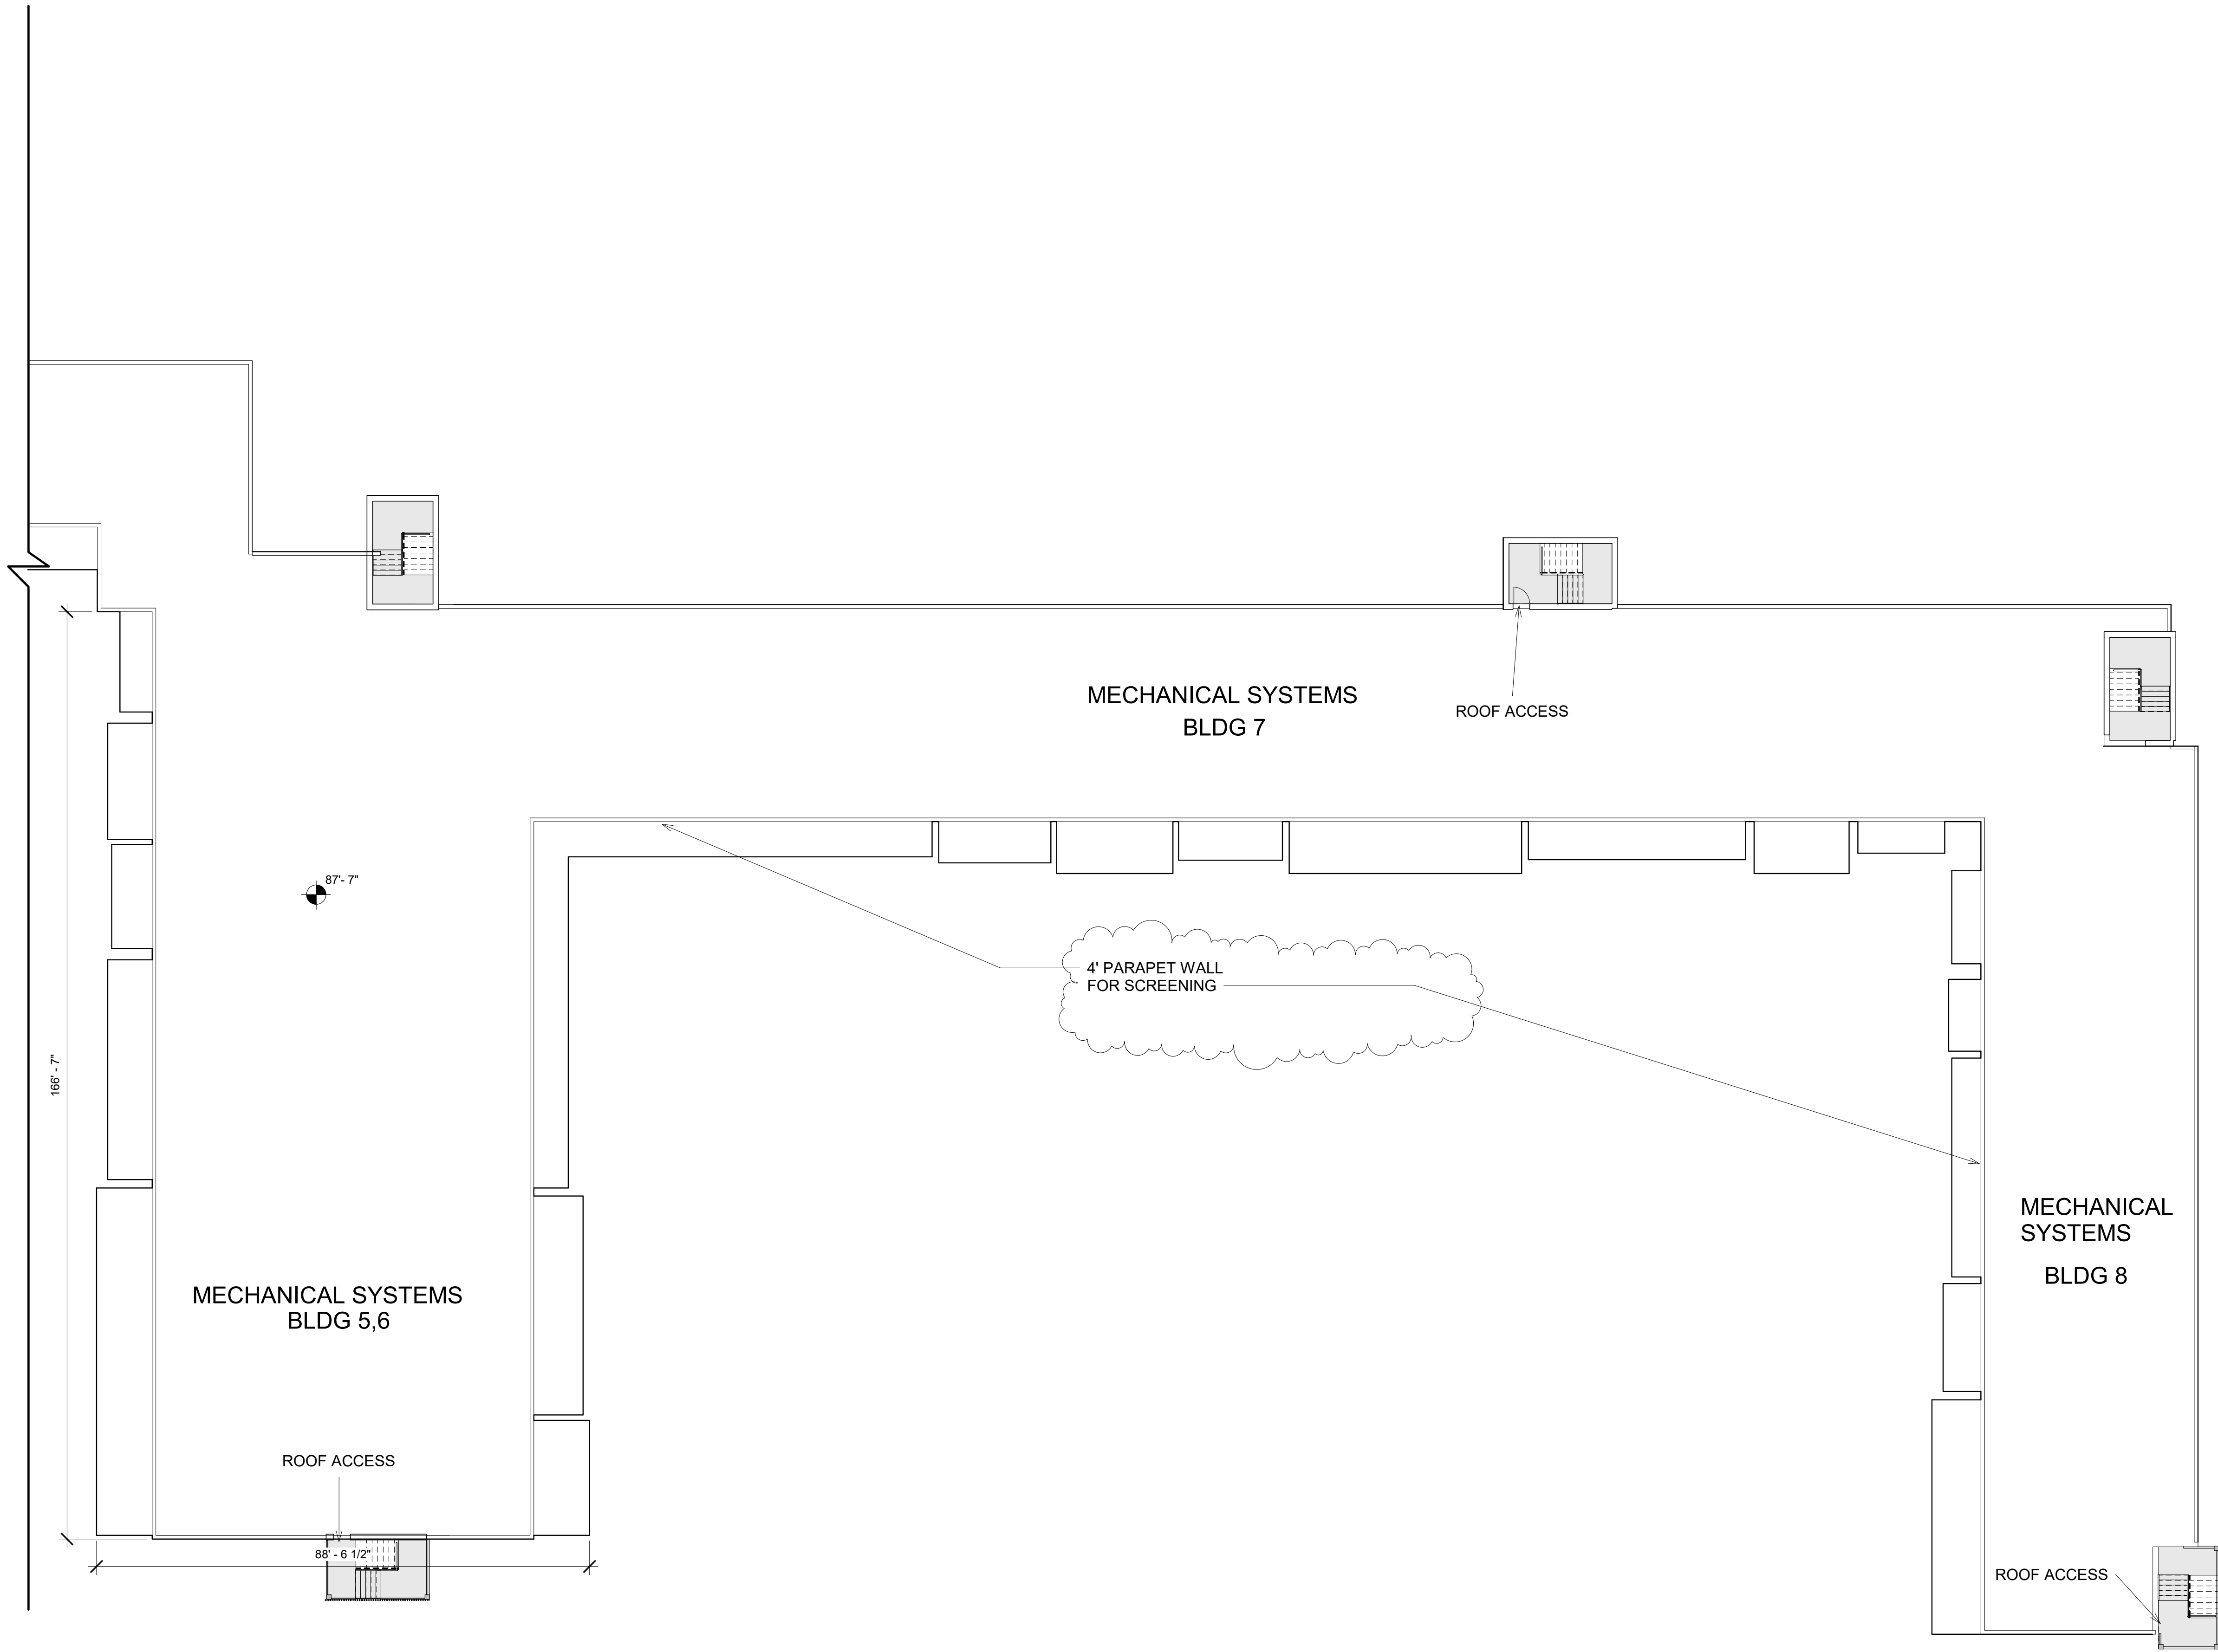

P I X L

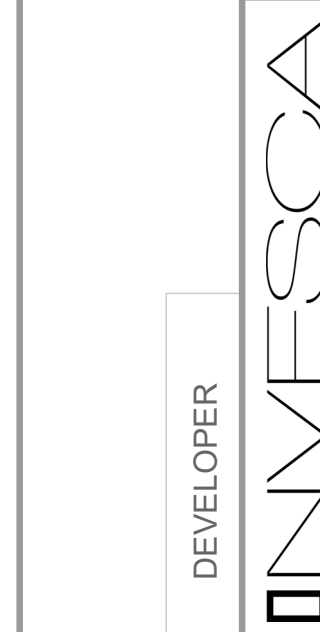

REVISIONS		DEVELOPER	
1	DRC SUBMITTAL	06-25-18	
2	PNZ SUBMITTAL	07-18-18	
3	CITY COUNCIL SUBMITTAL	03-06-19	

4400 NW 8TH COURT,
PLANTATION FL, 33317

ROOF PLAN BLDG 5,6,7,8 /
GARAGE EAST

PROJECT
ADDRESS

PIXL

SHEET
DESCRIPTION

ARCHITECT OF
RECORD

H.L.S. DESIGN
ASSOCIATES INC. AAC
001185
10710 NW 80 CIRCLE
PARKLAND, FL 33076

HARRY MUNOZ - R.A.
AR - 12033

MAR-6-19

N.R.

C.L

DATE

DRAWN

CHECKED

JOB #

7901

A110