



18071 - A1.02.01 - 19.07.11
PLOT : 19.07.11

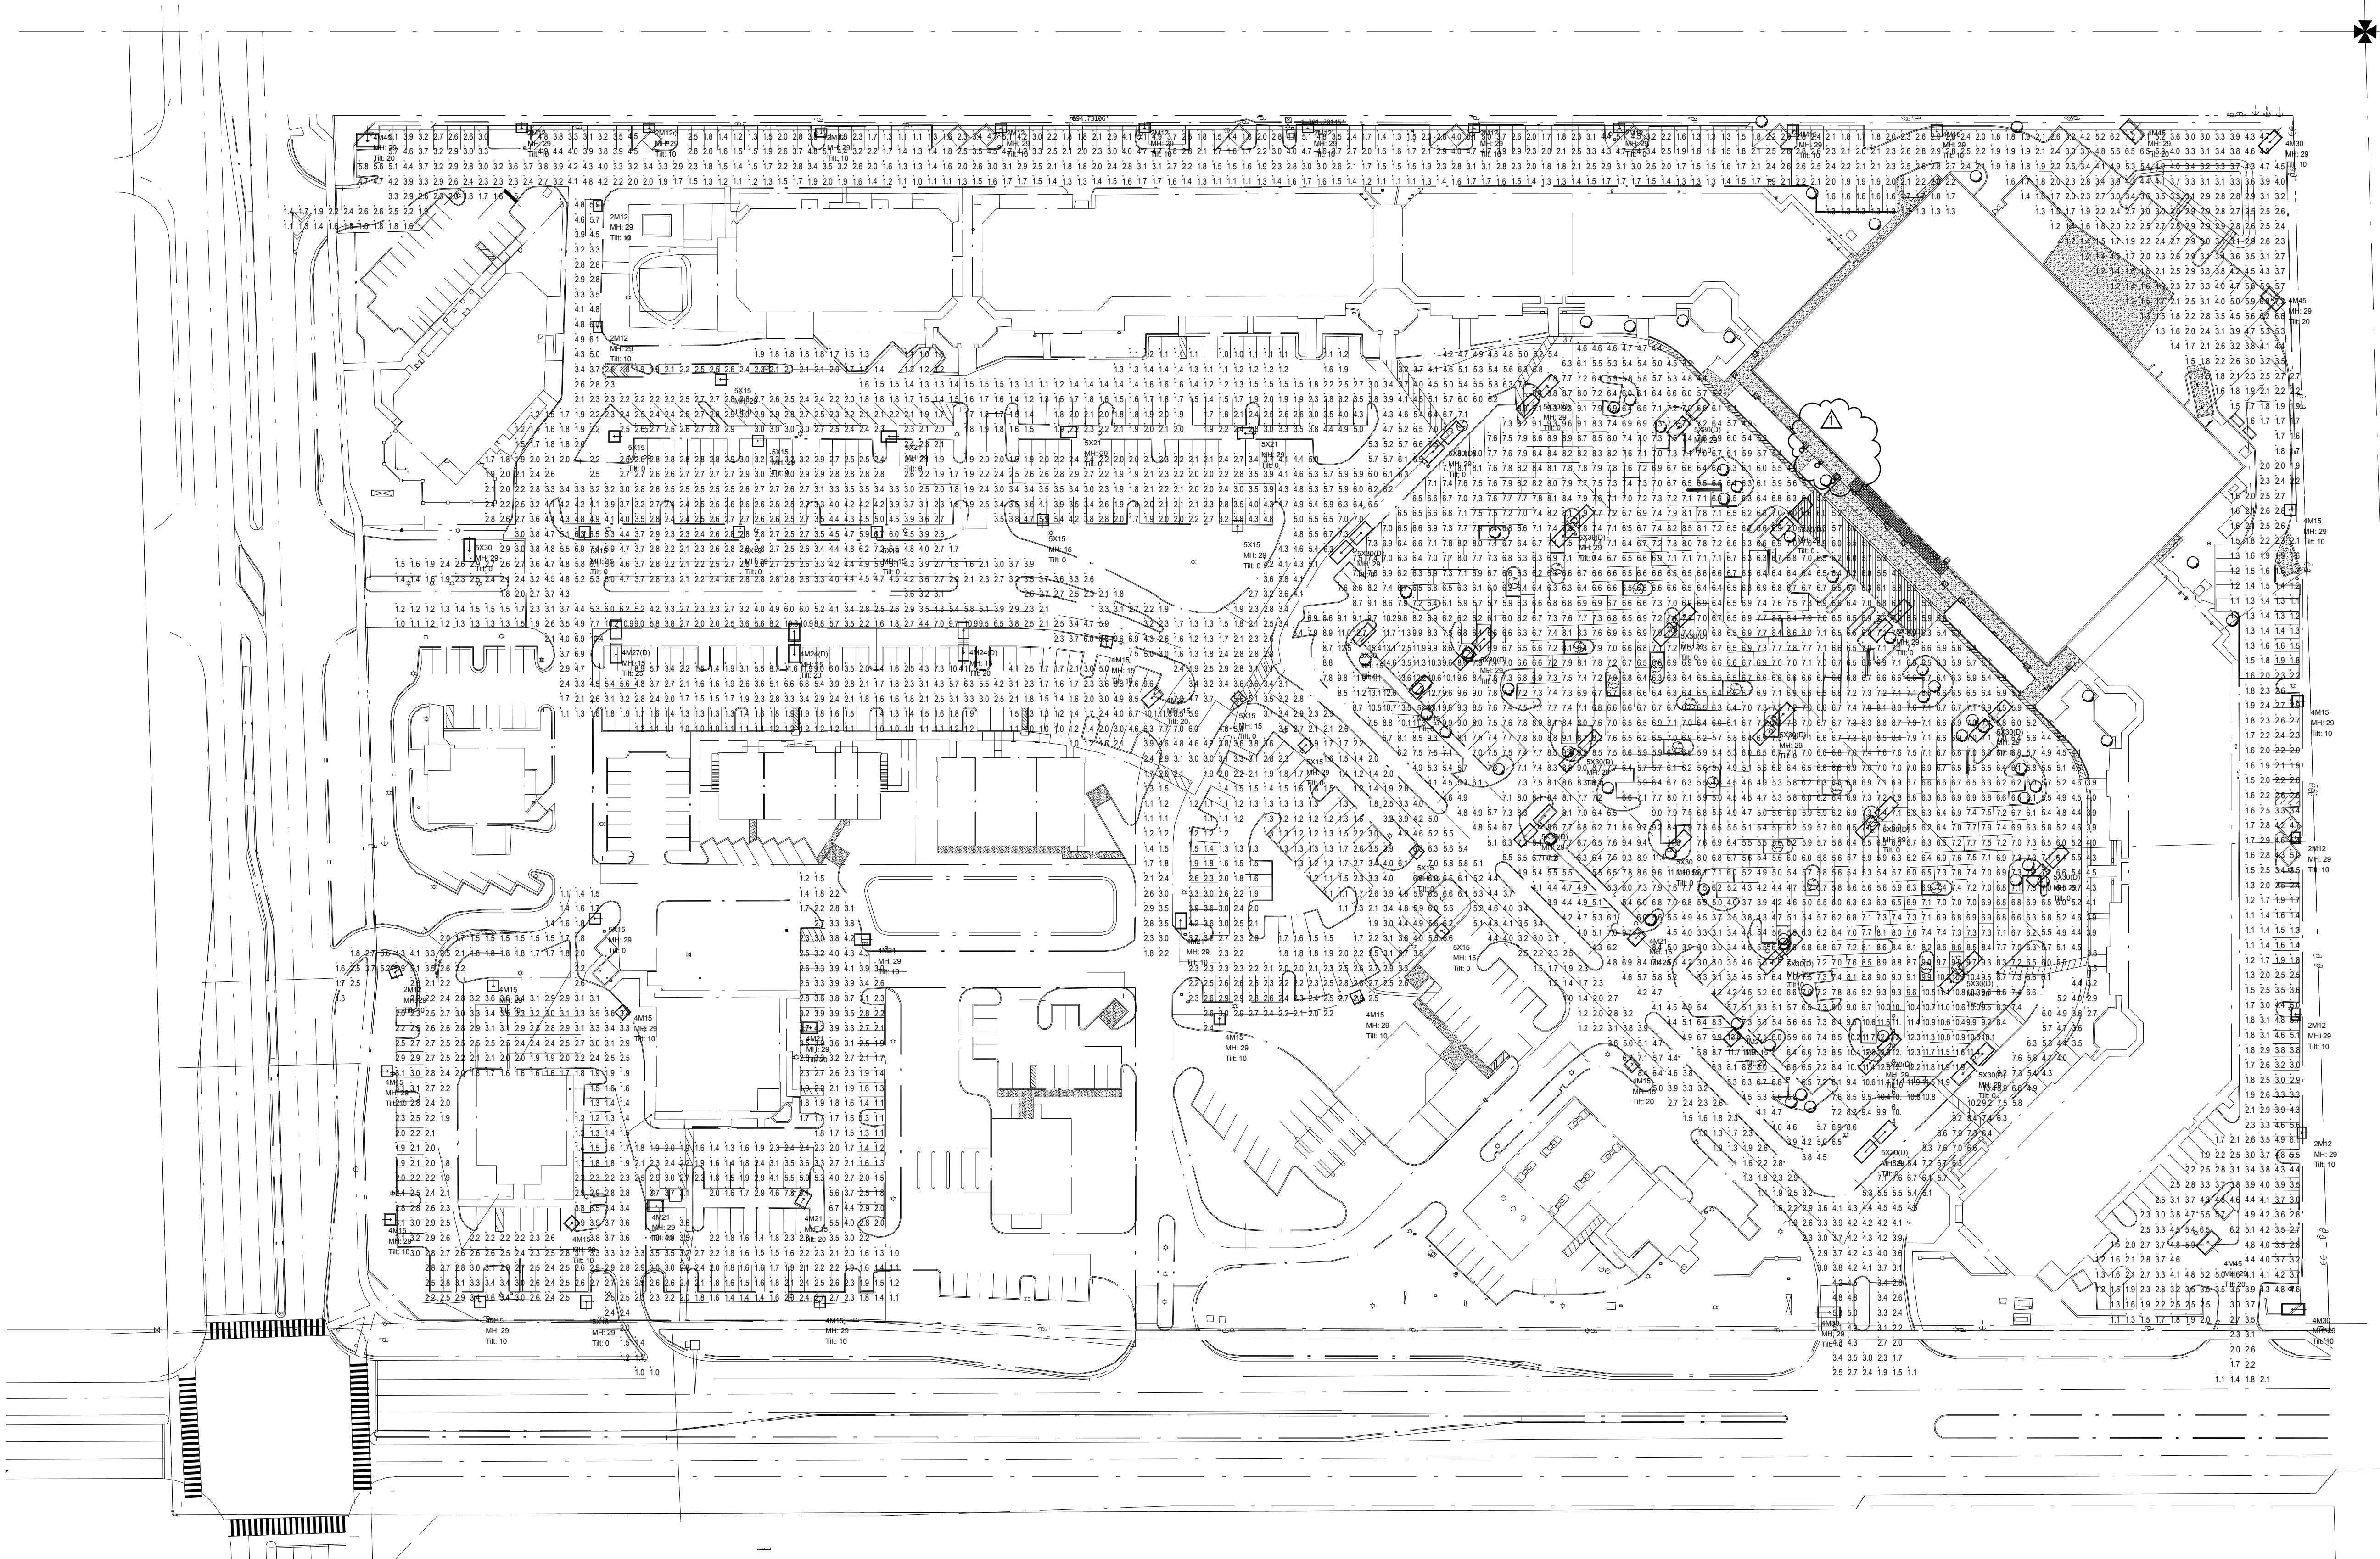

GENERAL REVISION

SITE LIGHTING PLAN

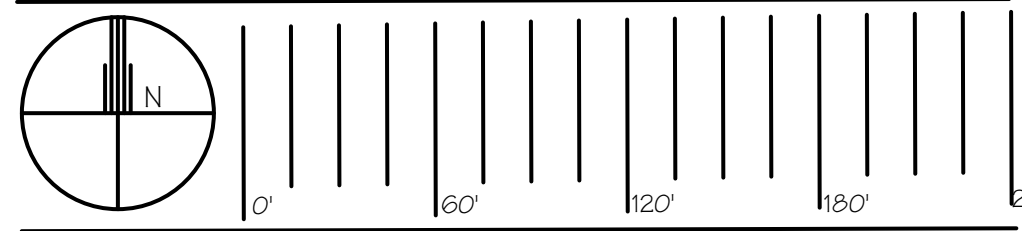


MARK	DESCRIPTION	DATE
△	SP COMMENT	9.30.19
△		
△		
MARC WIENER, AIA
Architecture / Planning

0: 561-750-4111
F: 561-750-5298

851 S FEDERAL HWY, SUITE 203
BOCA RATON, FLORIDA 33432

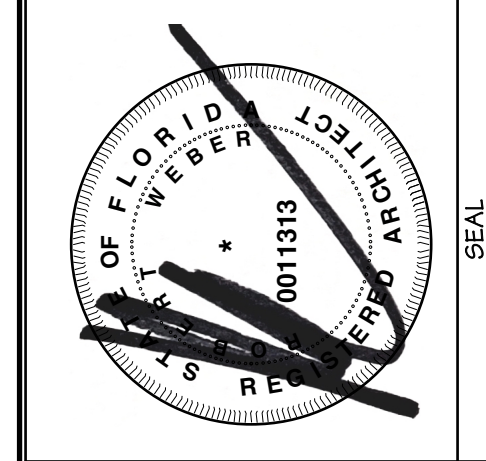

SOUTHEAST CENTERS, LLC
1541 Sunset Drive,
Suite 300
Coral Gables, FL 33143
Ph: 305.666.2140
Fax: 305.667.1586

PLANTATION PROMENADE
PUBX STORE #342 REPLACEMENT

PLANTATION PROMENADE
10065 CLEARY BLVD
PLANTATION, FLORIDA

JOB NUMBER	18071
SCALE	AS NOTED
ISSUE DATE	9.30.19
PERMIT DATE	
BID DATE	
DRAWN BY	
CHECKED BY	MW
DISCIPLINE	ARCHITECTURE
PLAN TYPE	
SHEET NUMBER	A1.02

KEY PLAN
REVISION BLOCK
ARCHITECT
OWNER IDENTIFICATION
BUILDING
SHEET