


Luminaire Schedule							
Symbol	Qty	Label	Arrangement	LLF	Description	Lum. Watts	Lum. Lumens
	14	2M12	SINGLE	0.969	LUMINOSO LOC 120W 2M AREA LIGHT	120.8	14801
	15	4M15	SINGLE	0.969	LUMINOSO LOC 150W 4M AREA LIGHT	149.1	18335
	7	4M21	SINGLE	0.969	LUMINOSO LOC 210W 4M AREA LIGHT	216.5	25842
	2	4M24(D)	BACK-BACK	0.969	LUMINOSO LOC 240W 4M AREA LIGHT	239.4	28962
	1	4M27	SINGLE	0.969	LUMINOSO LOC 270W 4M AREA LIGHT	269.9	32658
	1	4M27(D)	BACK-BACK	0.969	LUMINOSO LOC 270W 4M AREA LIGHT	269.9	32658
	3	4M30	SINGLE	0.969	LUMINOSO LOC 300W 4M AREA LIGHT	302.5	36568
	4	4M45	SINGLE	0.969	LUMINOSO LHO 450W 4M AREA LIGHT	481.1	54893
	13	5X15	SINGLE	0.969	LUMINOSO LOC 150W 5X AREA LIGHT	149.7	18058
	1	5X18	SINGLE	0.969	LUMINOSO LOC 180W 5X AREA LIGHT	185.8	21560
	3	5X21	SINGLE	0.969	LUMINOSO LOC 210W 5X AREA LIGHT	213.3	25464
	4	5X30	SINGLE	0.969	LUMINOSO LOC 300W 5X AREA LIGHT	304.1	35671
	20	5X30(D)	BACK-BACK	0.969	LUMINOSO LOC 300W 5X AREA LIGHT	304.1	35671
	3	15W LED	WALL SCONCE		RAB LIGHTING GN1LED13NRACB TO MATCH EXISTING	15	

Calculation Summary							
Label	CalcType	Units	Avg	Max	Min	Avg/Min	Max/Min
Back	Illuminance	Fc	2.65	7.2	1.0	2.65	7.20
Front	Illuminance	Fc	3.01	11.9	1.0	3.01	11.90
Publix	Illuminance	Fc	7.02	15.4	3.0	2.34	5.13

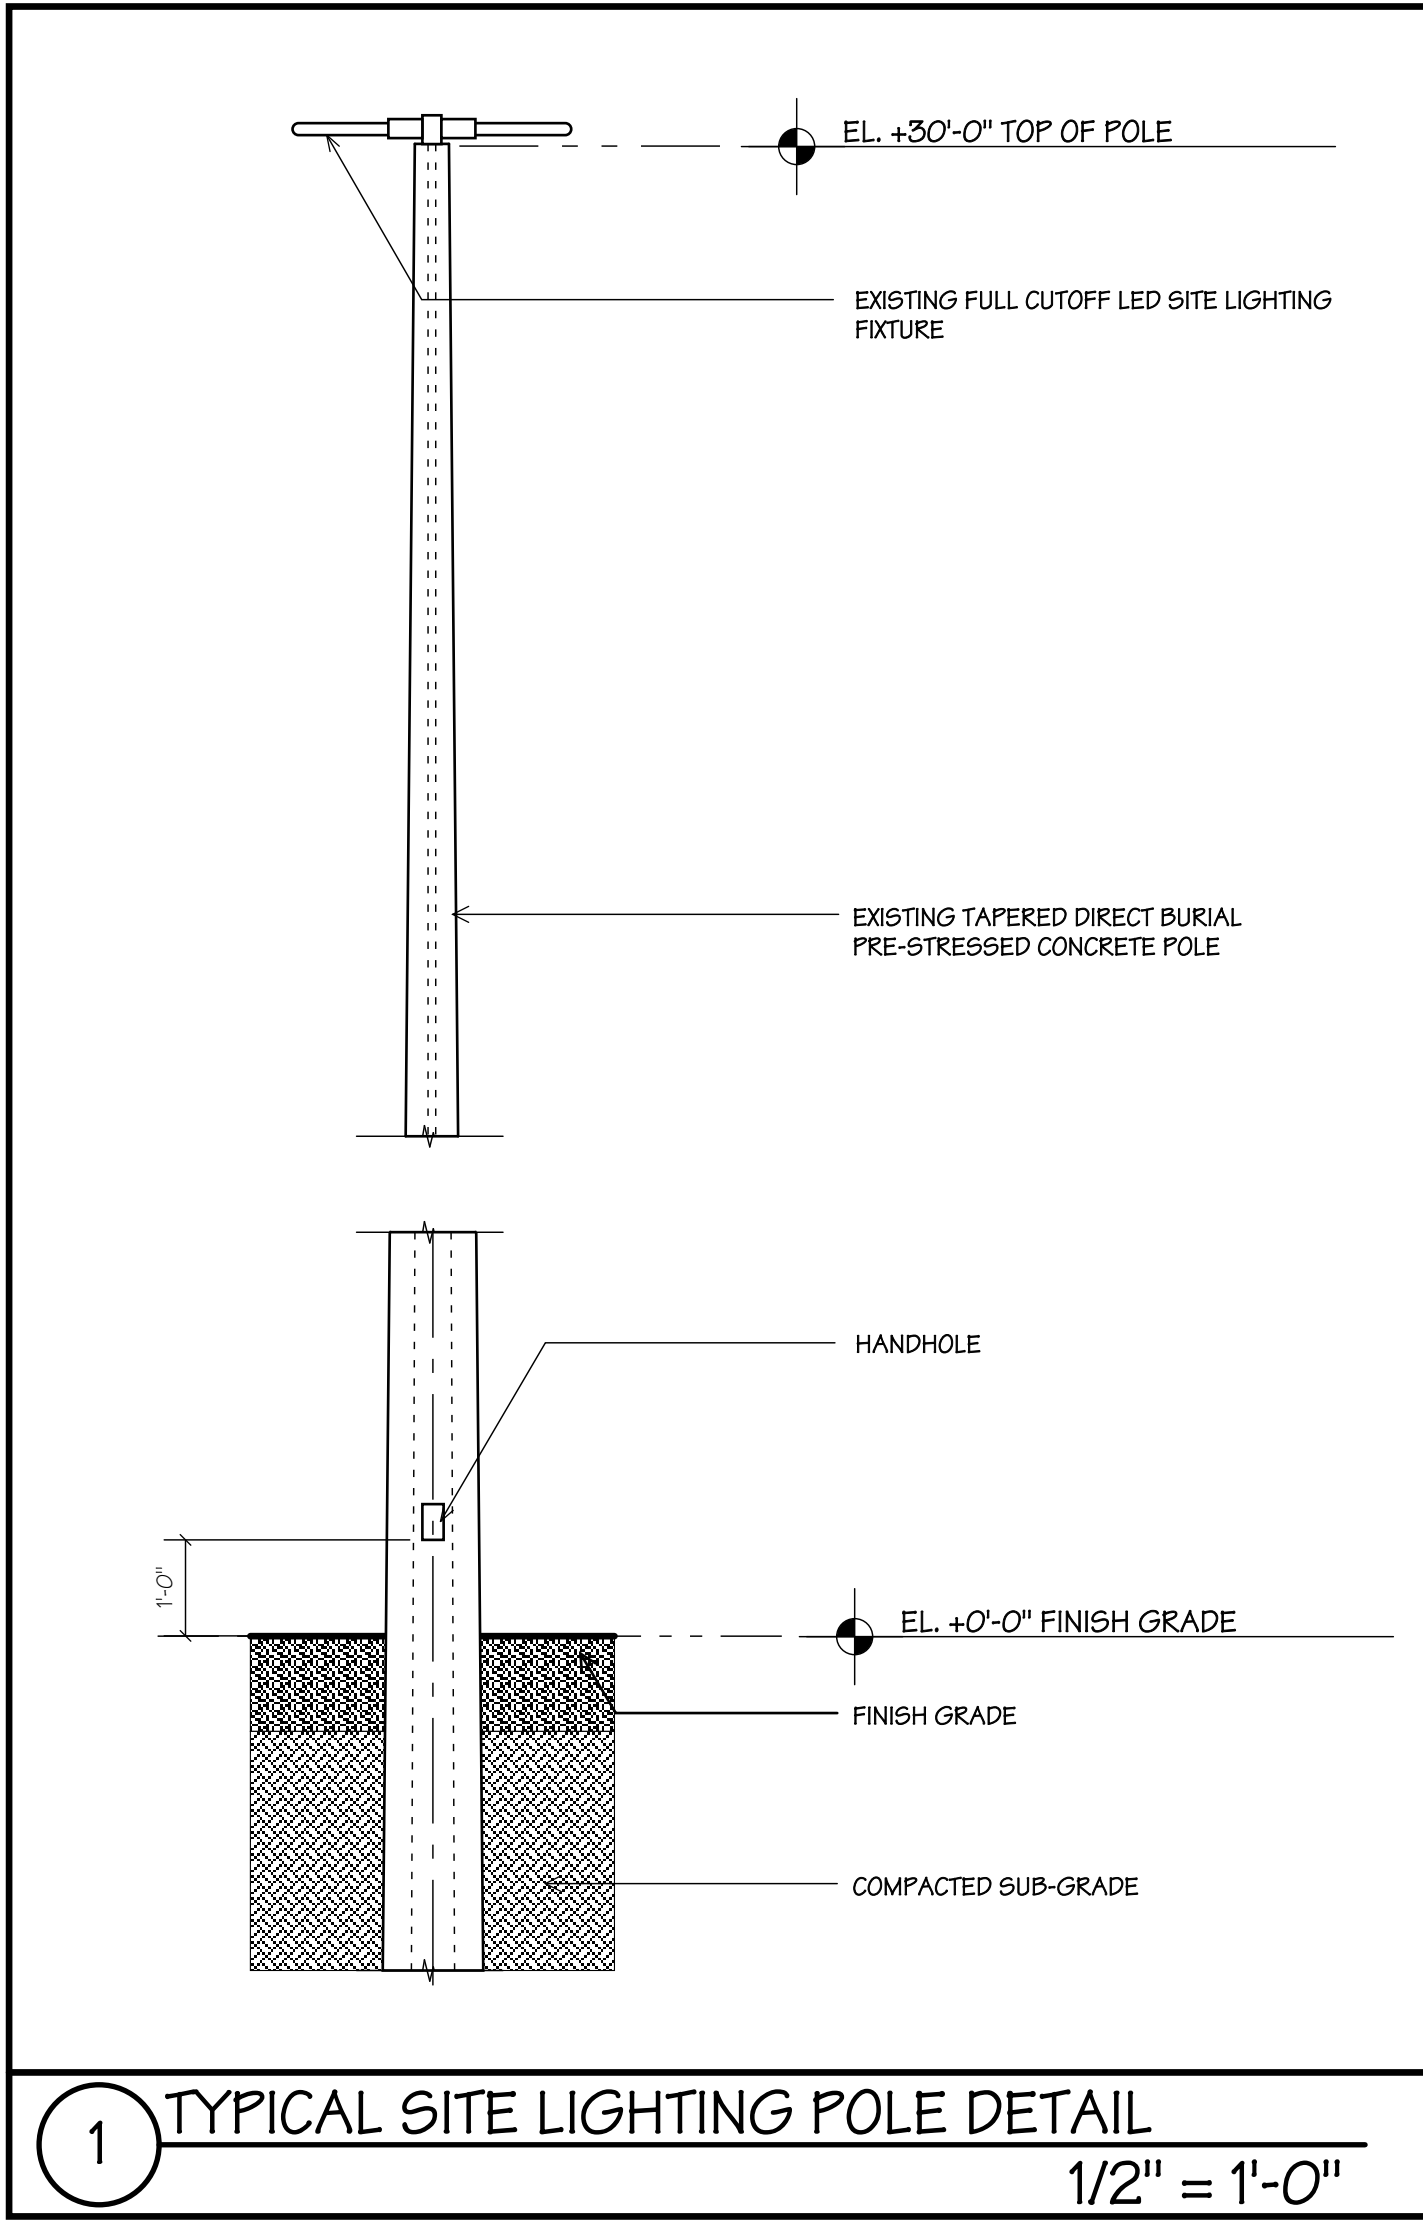


© 2019 MARC WIENER, AIA




KEY PLAN

MARK	DESCRIPTION	DATE
	SP COMMENT	9.30.19
		
		
		
		
		
		
		

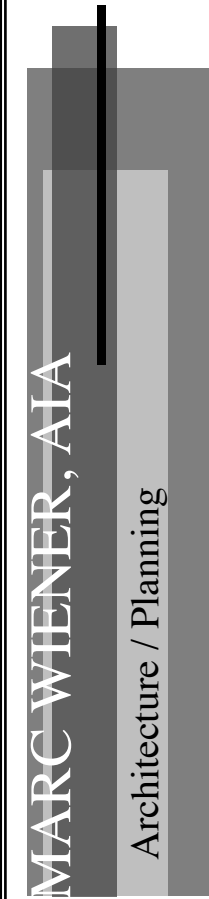

Architecture / Planning

851 S FEDERAL HWY, SUITE 203
BOCA RATON, FLORIDA 33432
O: 561-750-4111
F: 561-750-5298

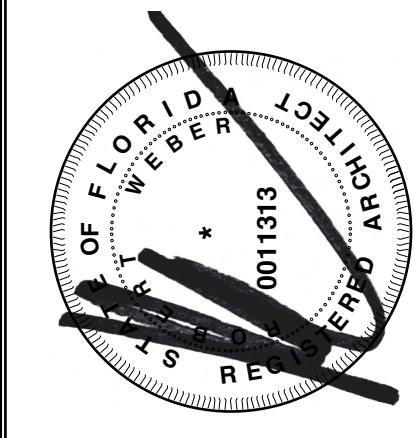

SOUTHEAST CENTERS, LLC
1541 Sunset Drive,
Suite 300
Coral Gables, FL 33143
Ph: 305.666.2140
Fax: 305.667.1586

OWNER REPRESENTATION

PLANTATION PROMENADE
PUBLIX STORE #342 REPLACEMENT

PLANTATION PROMENADE
10065 CLEARY BLVD
PLANTATION, FLORIDA

BUILDING

JOB NUMBER	18071	PROJECT
SCALE	AS NOTED	
ISSUE DATE	9.30.19	
PERMIT DATE		
BID DATE		
DRAWN BY		SHEET
CHECKED BY	MW	
DISCIPLINE	ARCHITECTURE	
PLAN TYPE		
SHEET NUMBER	A1.03	